

920 LANGDALE DR. FORT COLLINS, CO


BEAUTIFUL MODERN TRADITIONAL
2813 SF TWO STORY SINGLE FAMILY HOME BUILT
AND DESIGNED BY SAVANT DESIGN+BUILD



EXTERIOR PERSPECTIVE - ENTRY
SCALE: N.T.S.



EXTERIOR PERSPECTIVE - REAR
SCALE: N.T.S.

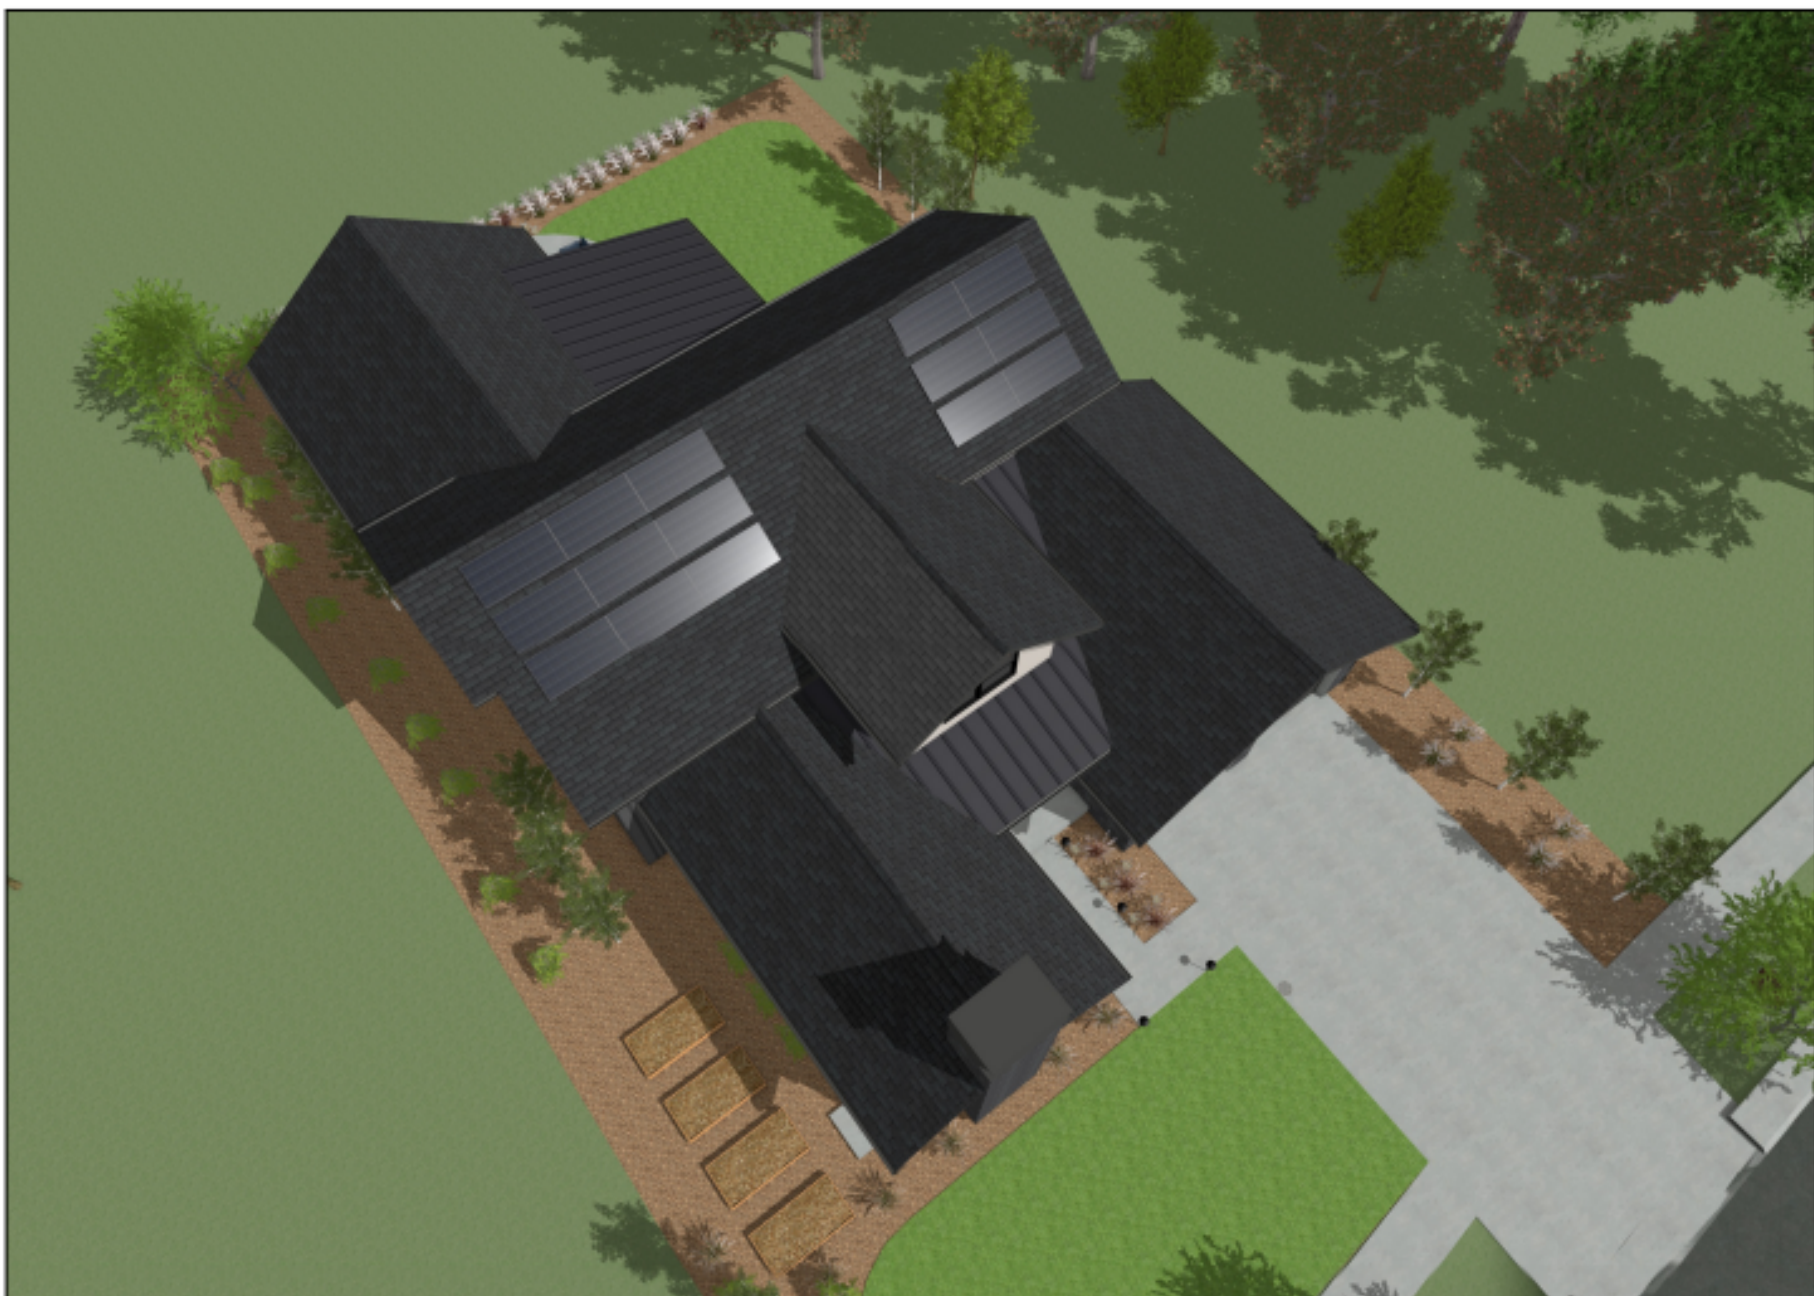





EXTERIOR PERSPECTIVE - BIRDS EYE
SCALE: N.T.S.




RENDERINGS AND PHOTOS
ARE FOR INSPIRATION ONLY.
MATERIALS ARE SUBJECT TO
CHANGE PER BUILDER

EXTERIOR FINISHES

Color Palette

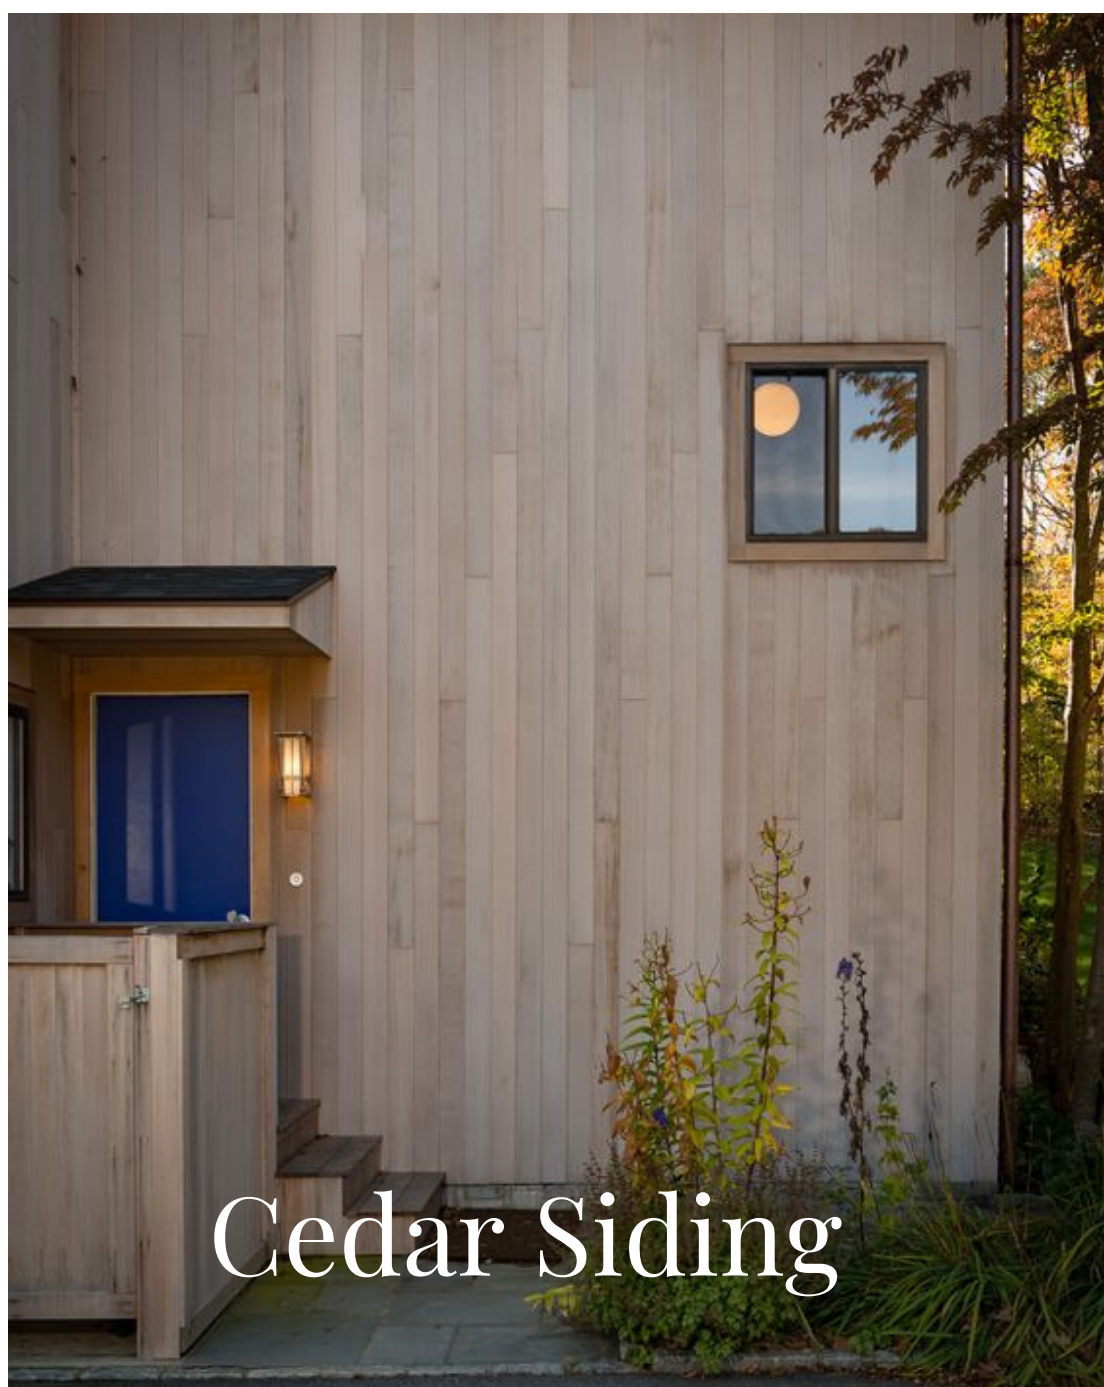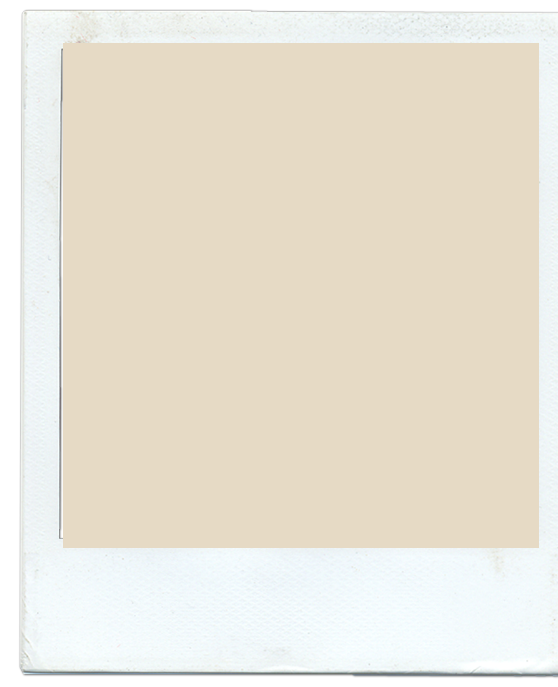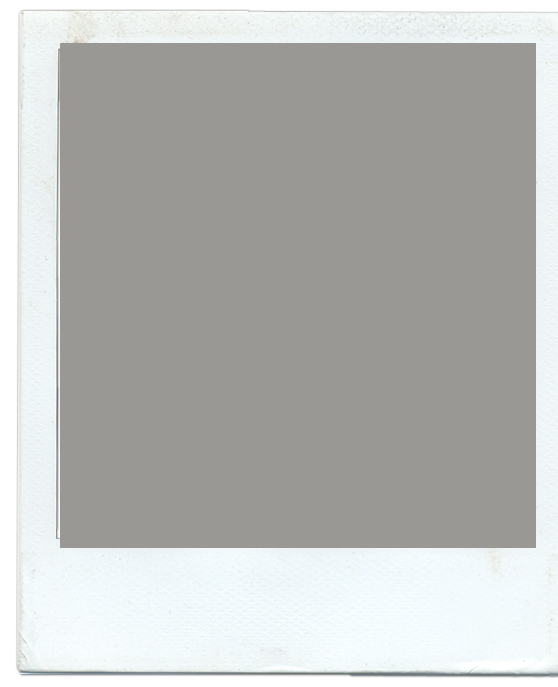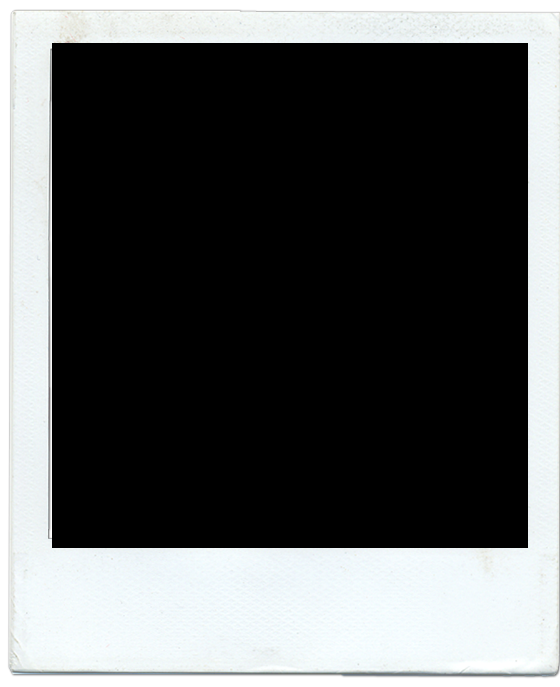


Cedar Siding

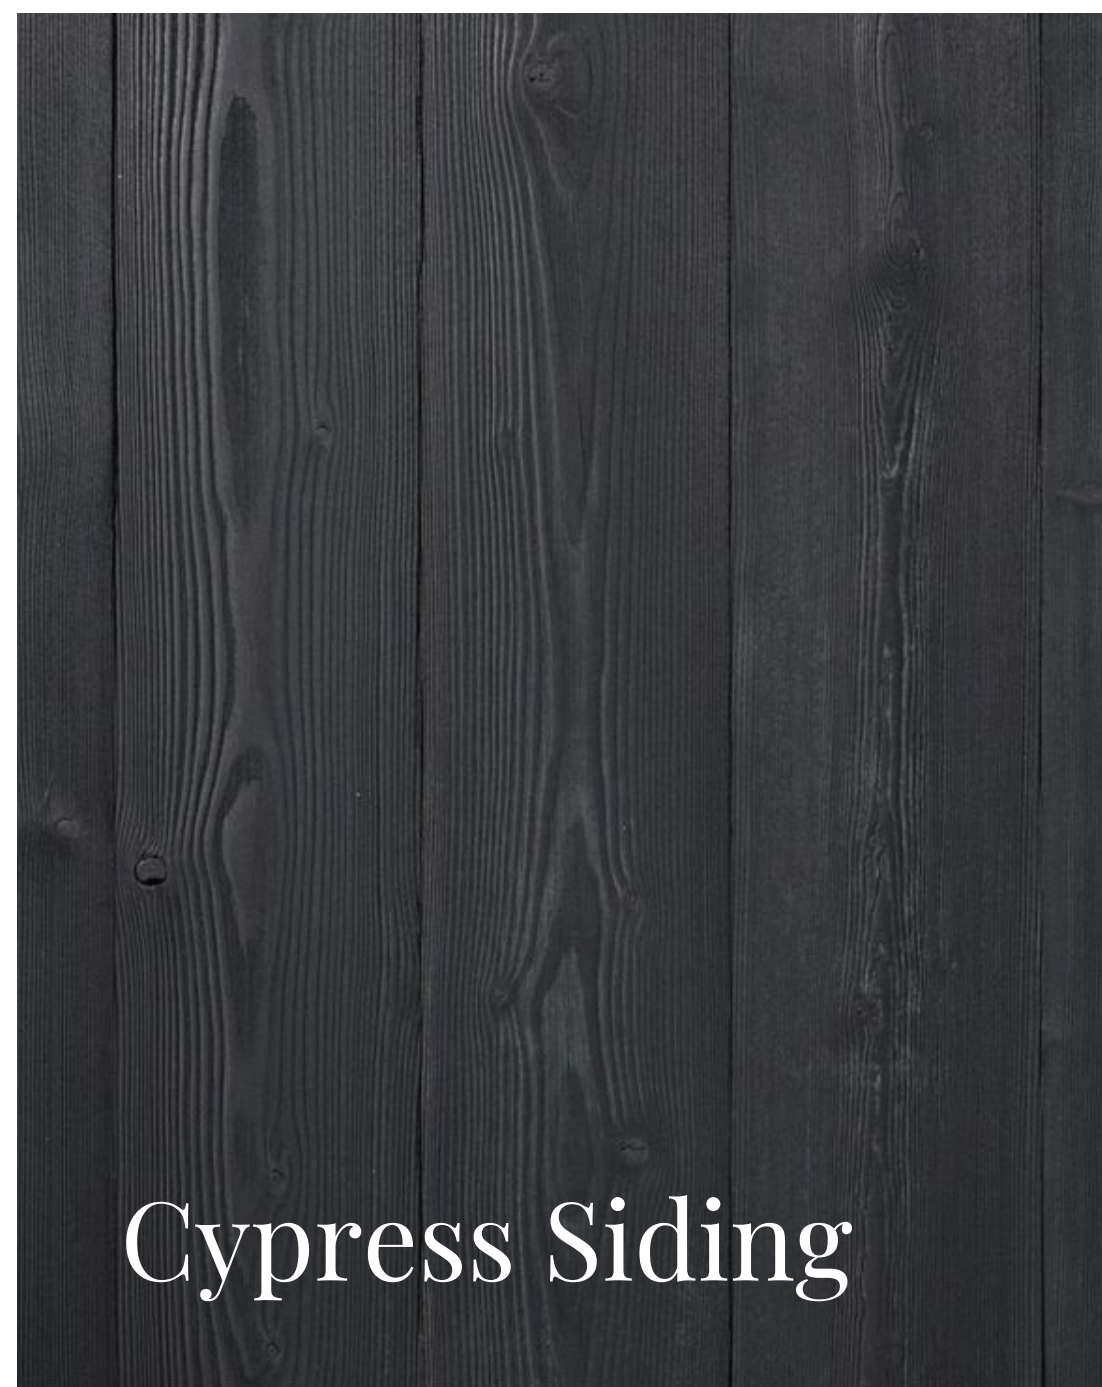


Cypress Siding




Garage Doors

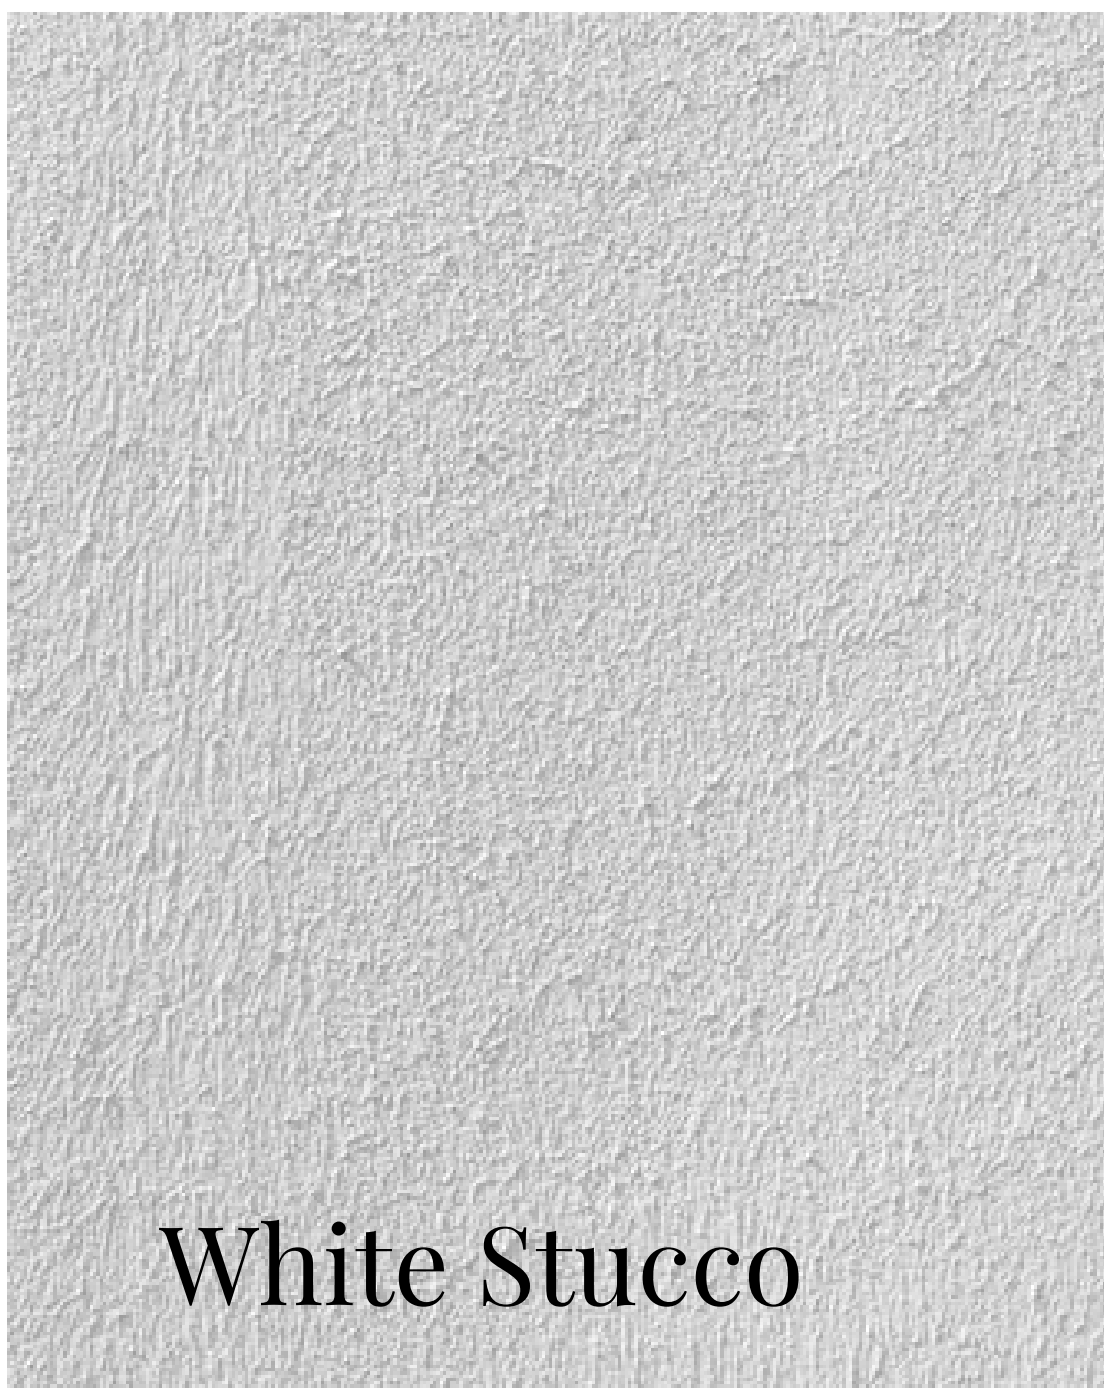

White Stucco

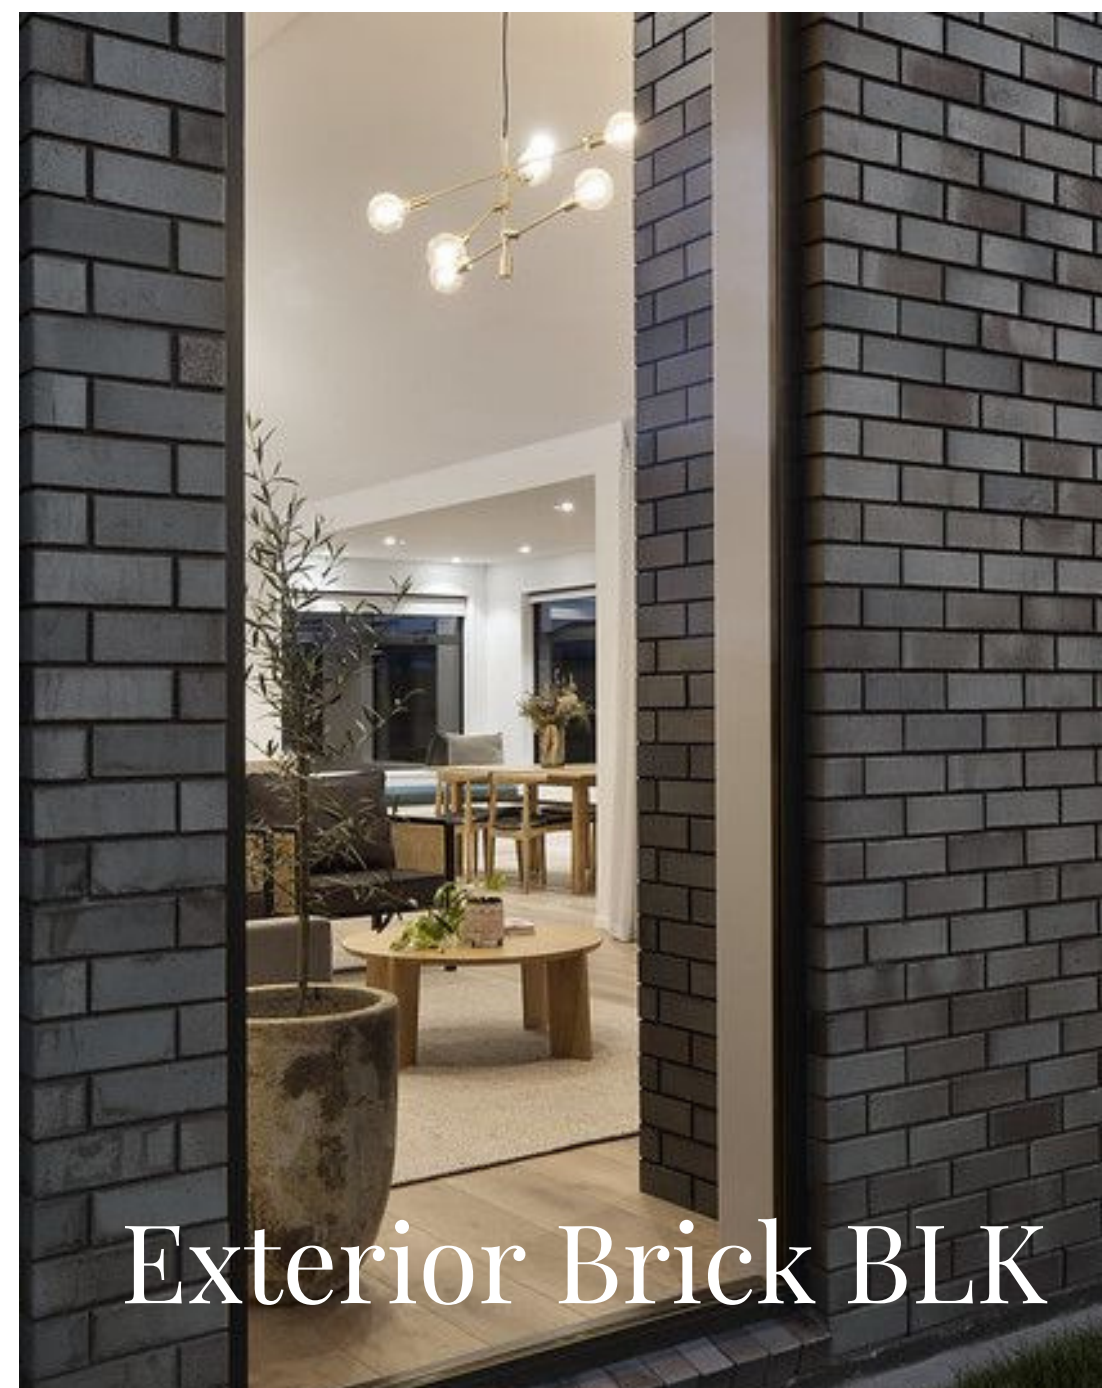

Exterior Brick BLK

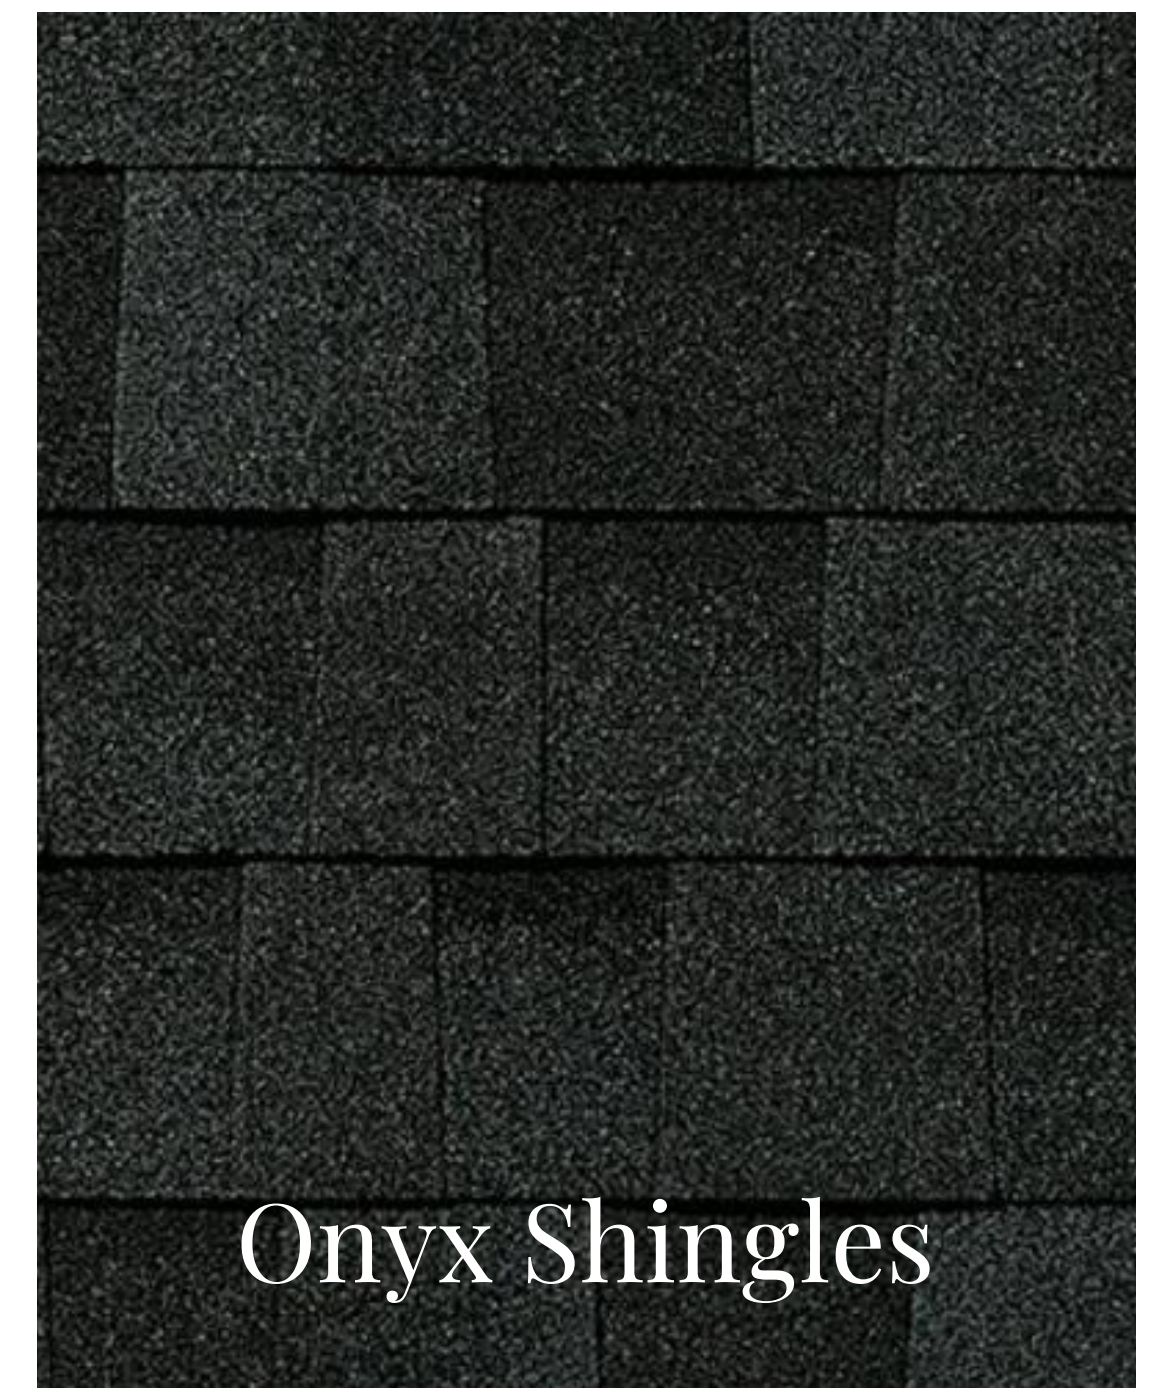

Onyx Shingles



BLK Windows



BLK Gutters



BLK Metal Accent Roof


INTERIOR DESIGN DIRECTION

MAIN LEVEL



FLOOR PLAN

MAIN LEVEL 1930 SF
9' CEILING HEIGHT
8' INTERIOR DOOR HEIGHT
MAIN FLOOR PRIMARY BED/BATH
IN-HOME OFFICE SUITE
1ST FLOOR LAUNDRY/MUDROOM
KITCHEN/LIVING/DINING/POWDER BATH
2 CAR OVERSIZED 550SF GARAGE

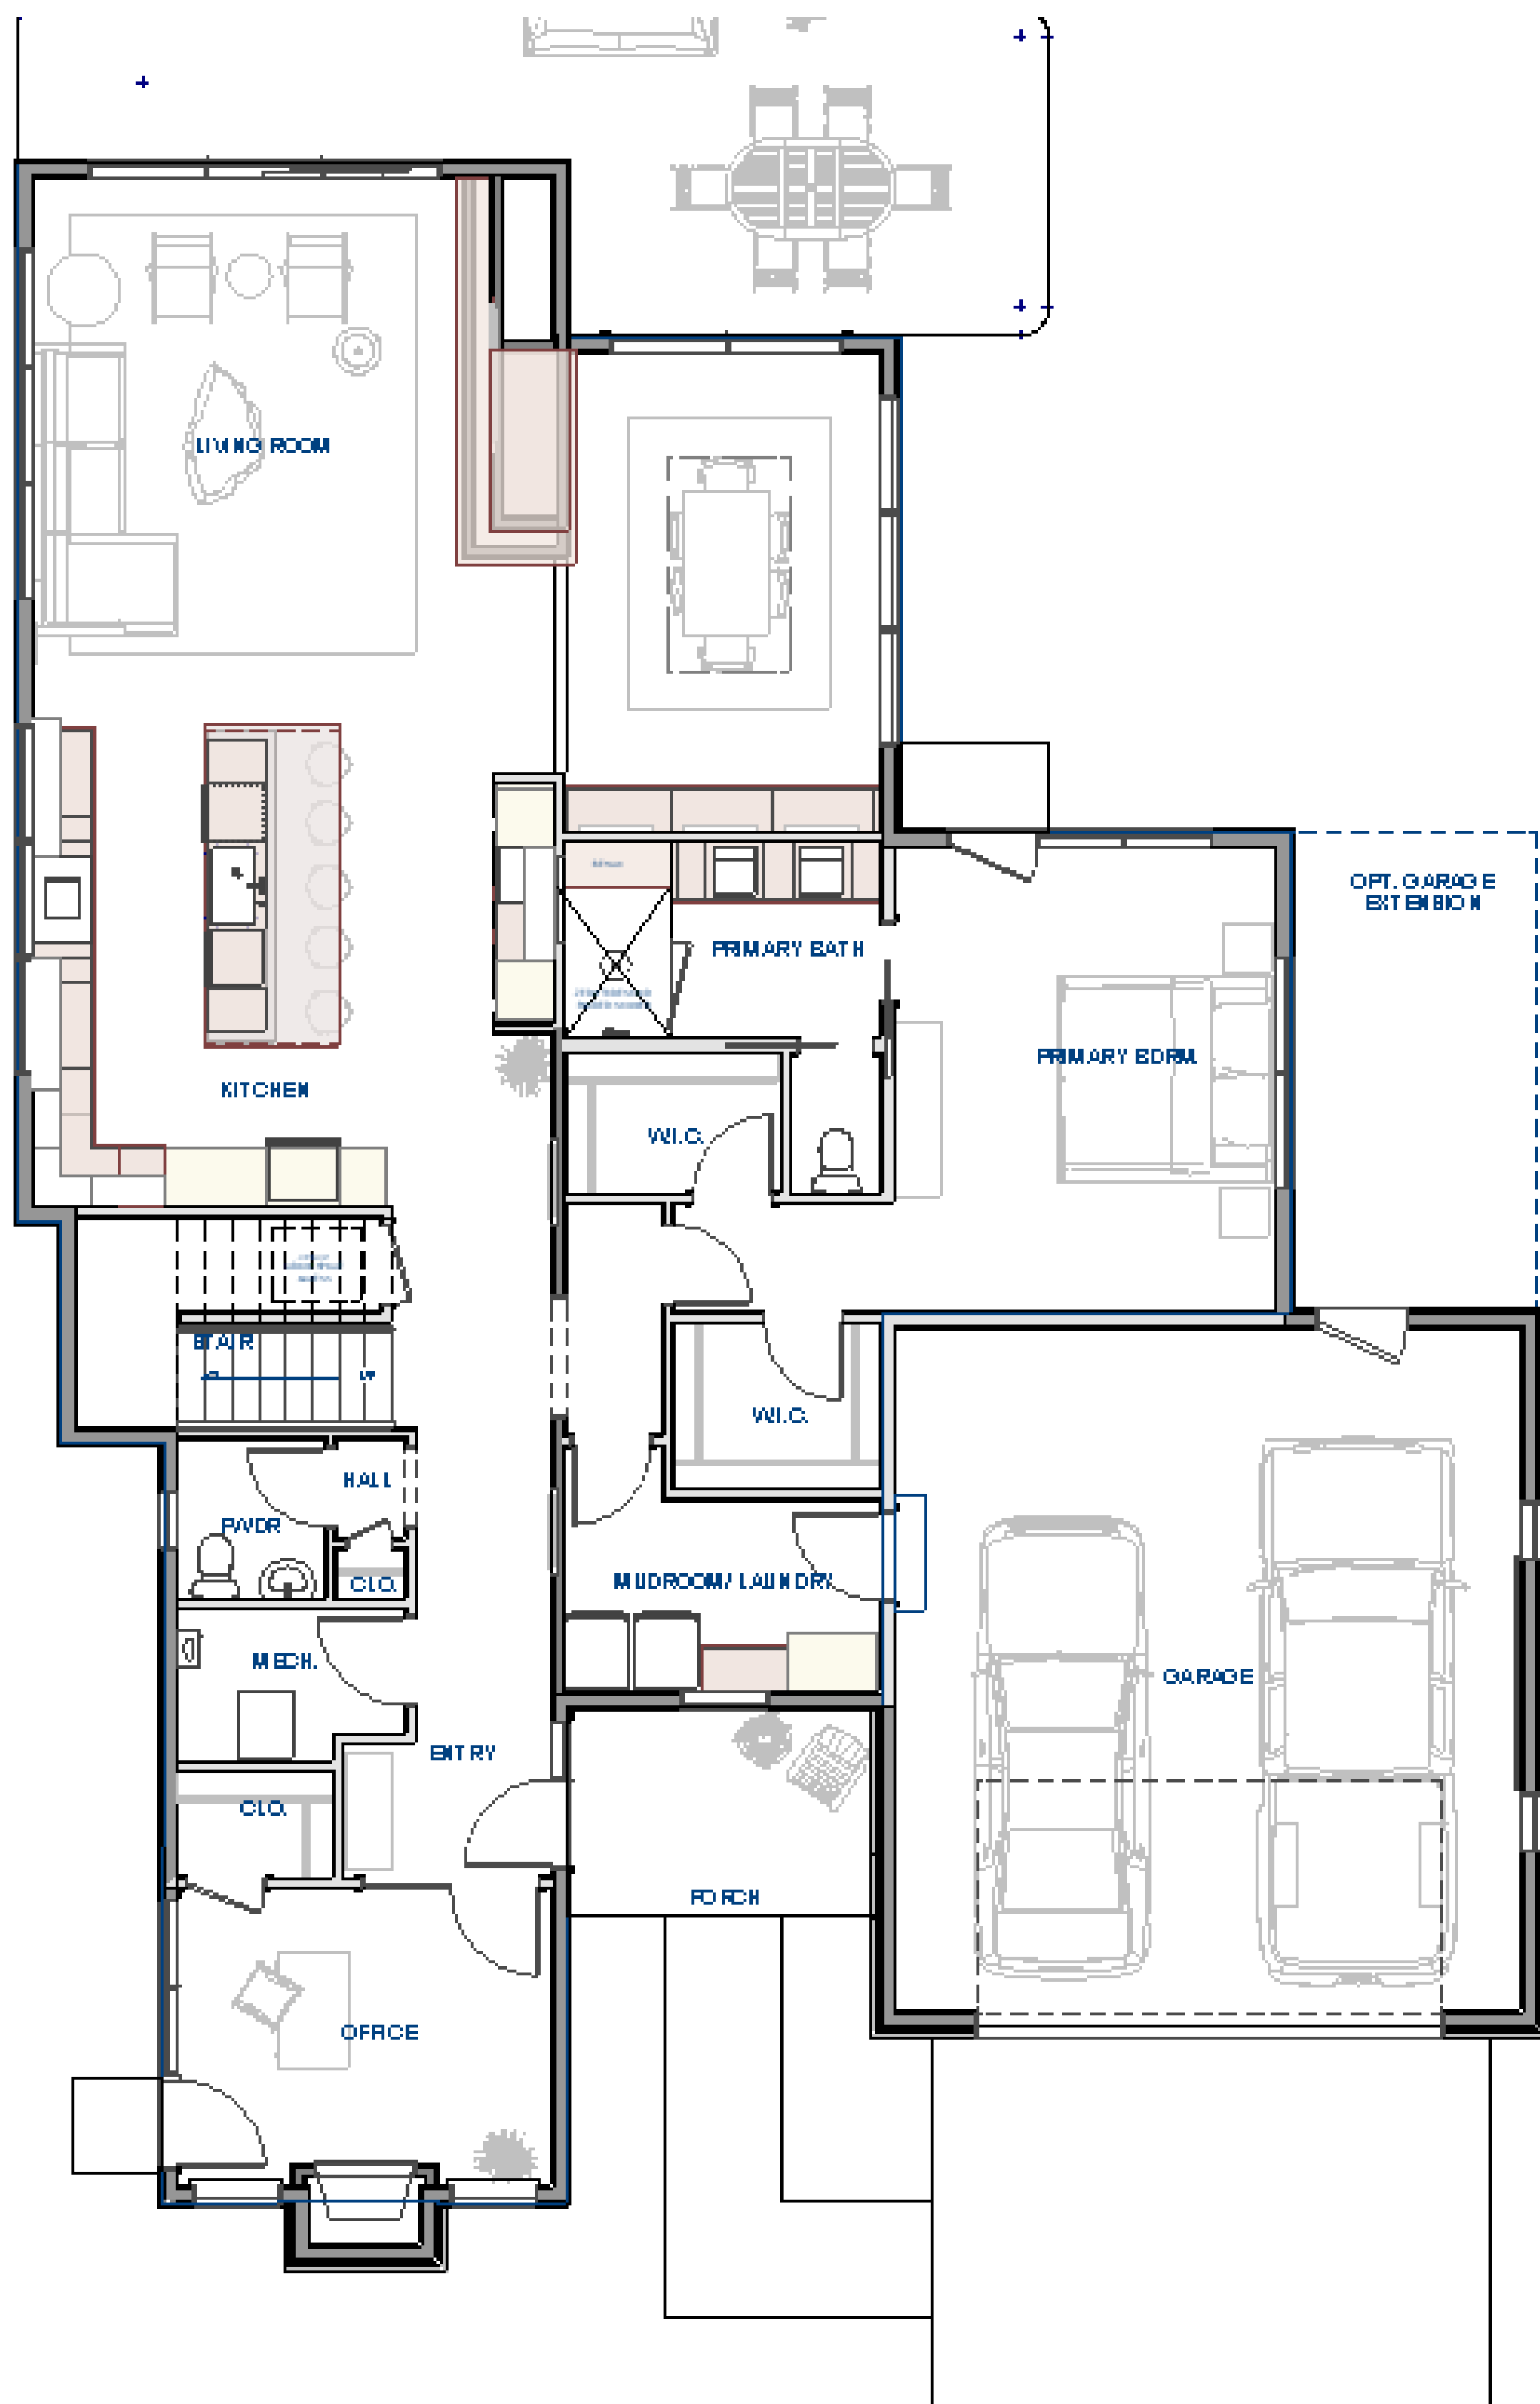


INTERIOR FINISHES



Flooring



**Metal Railing
With wood stairs
and Handrail**

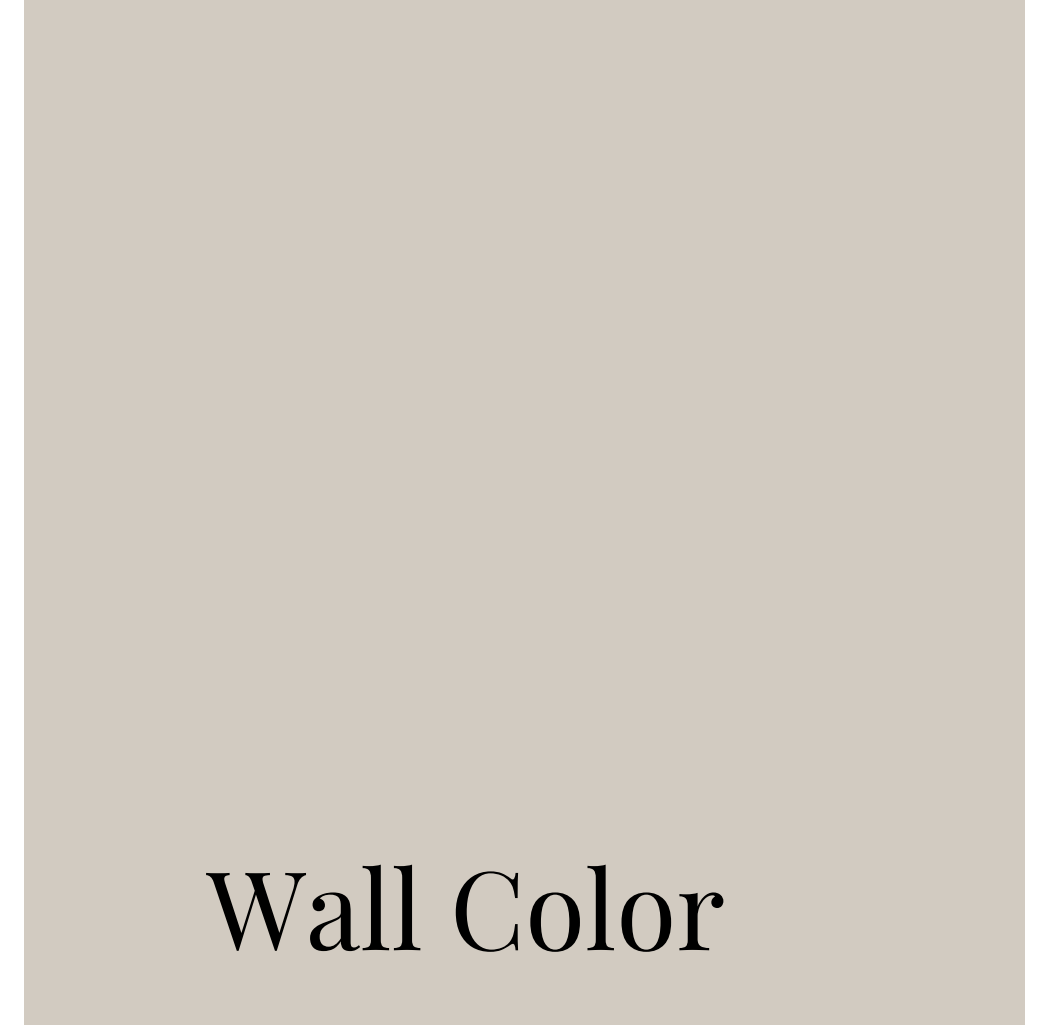

Wall Color



Trim/Doors




Door Trim



Interior Doors



Floor Base Trim

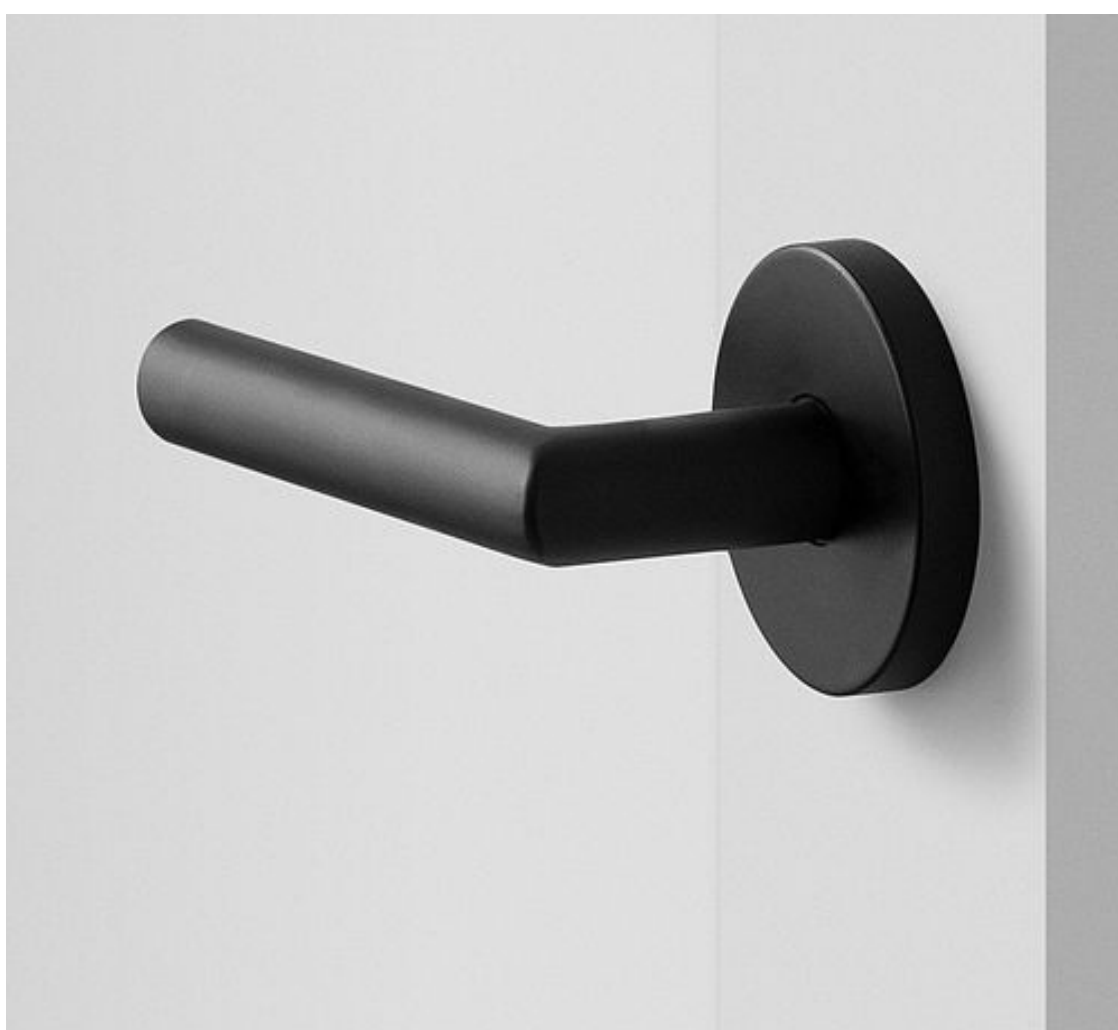

BLK Door Hardware



Level 5 Smooth Texture


OFFICE



Office Inspiration



Lighting

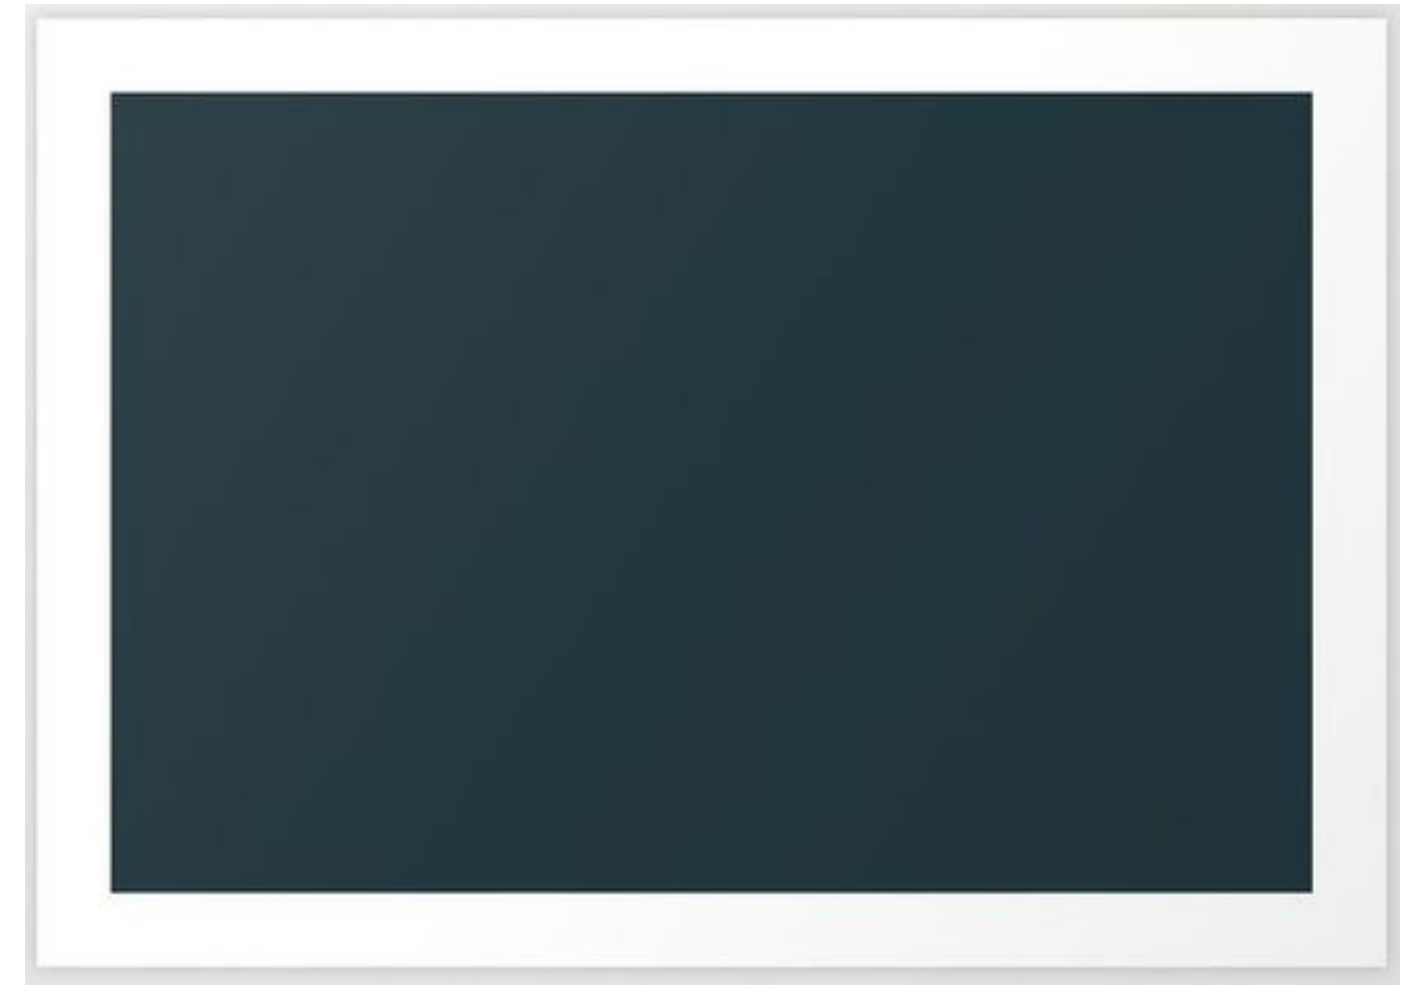


Wall Color



Fireplace



Flooring

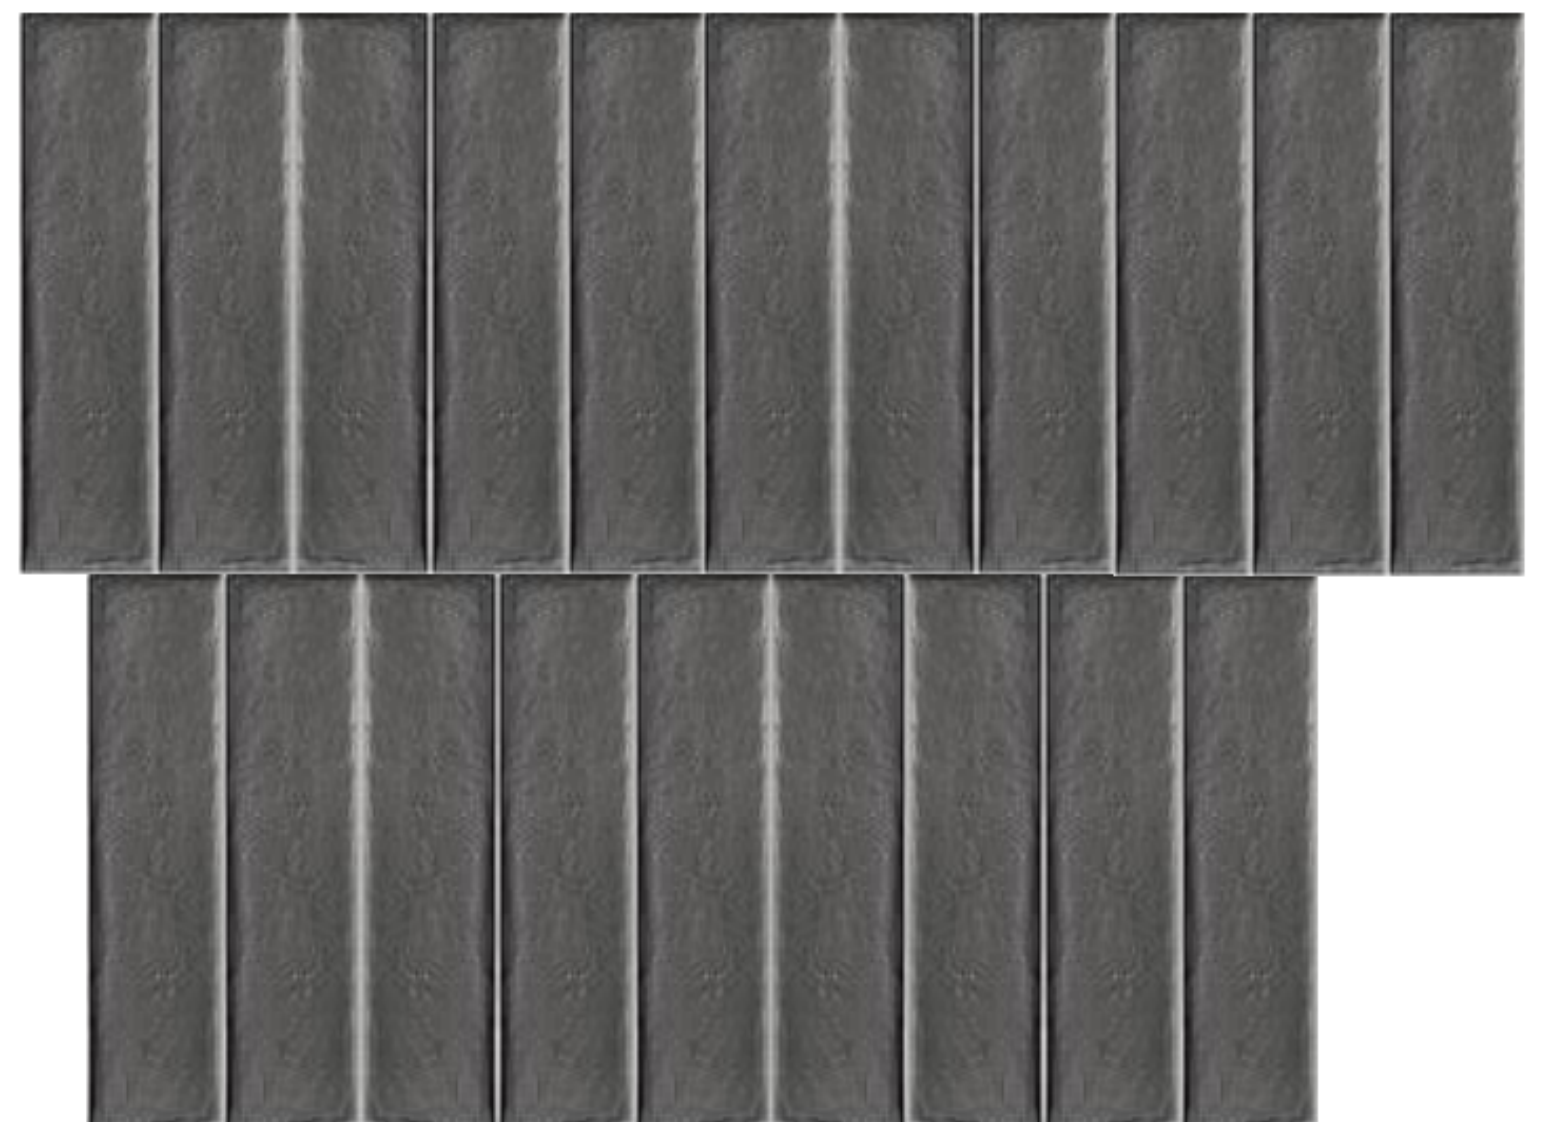

FP Tile

POWDER BATH



Wall Sconces



Arched Mirror



Two Handle Faucet BLK



Wall Tile Behind Sink
And Toilet Floor to Ceiling



Pedestal Sink WHT



Flooring



Bath Hardware BLK



Toto Toilet with
BLK Flush

KITCHEN



Two Toned
Cabinets



Quartz Countertops
Perimeter and Backsplash




LVP Flooring



Cabinet Hardware

Quartzite Countertop
Island with Waterfall

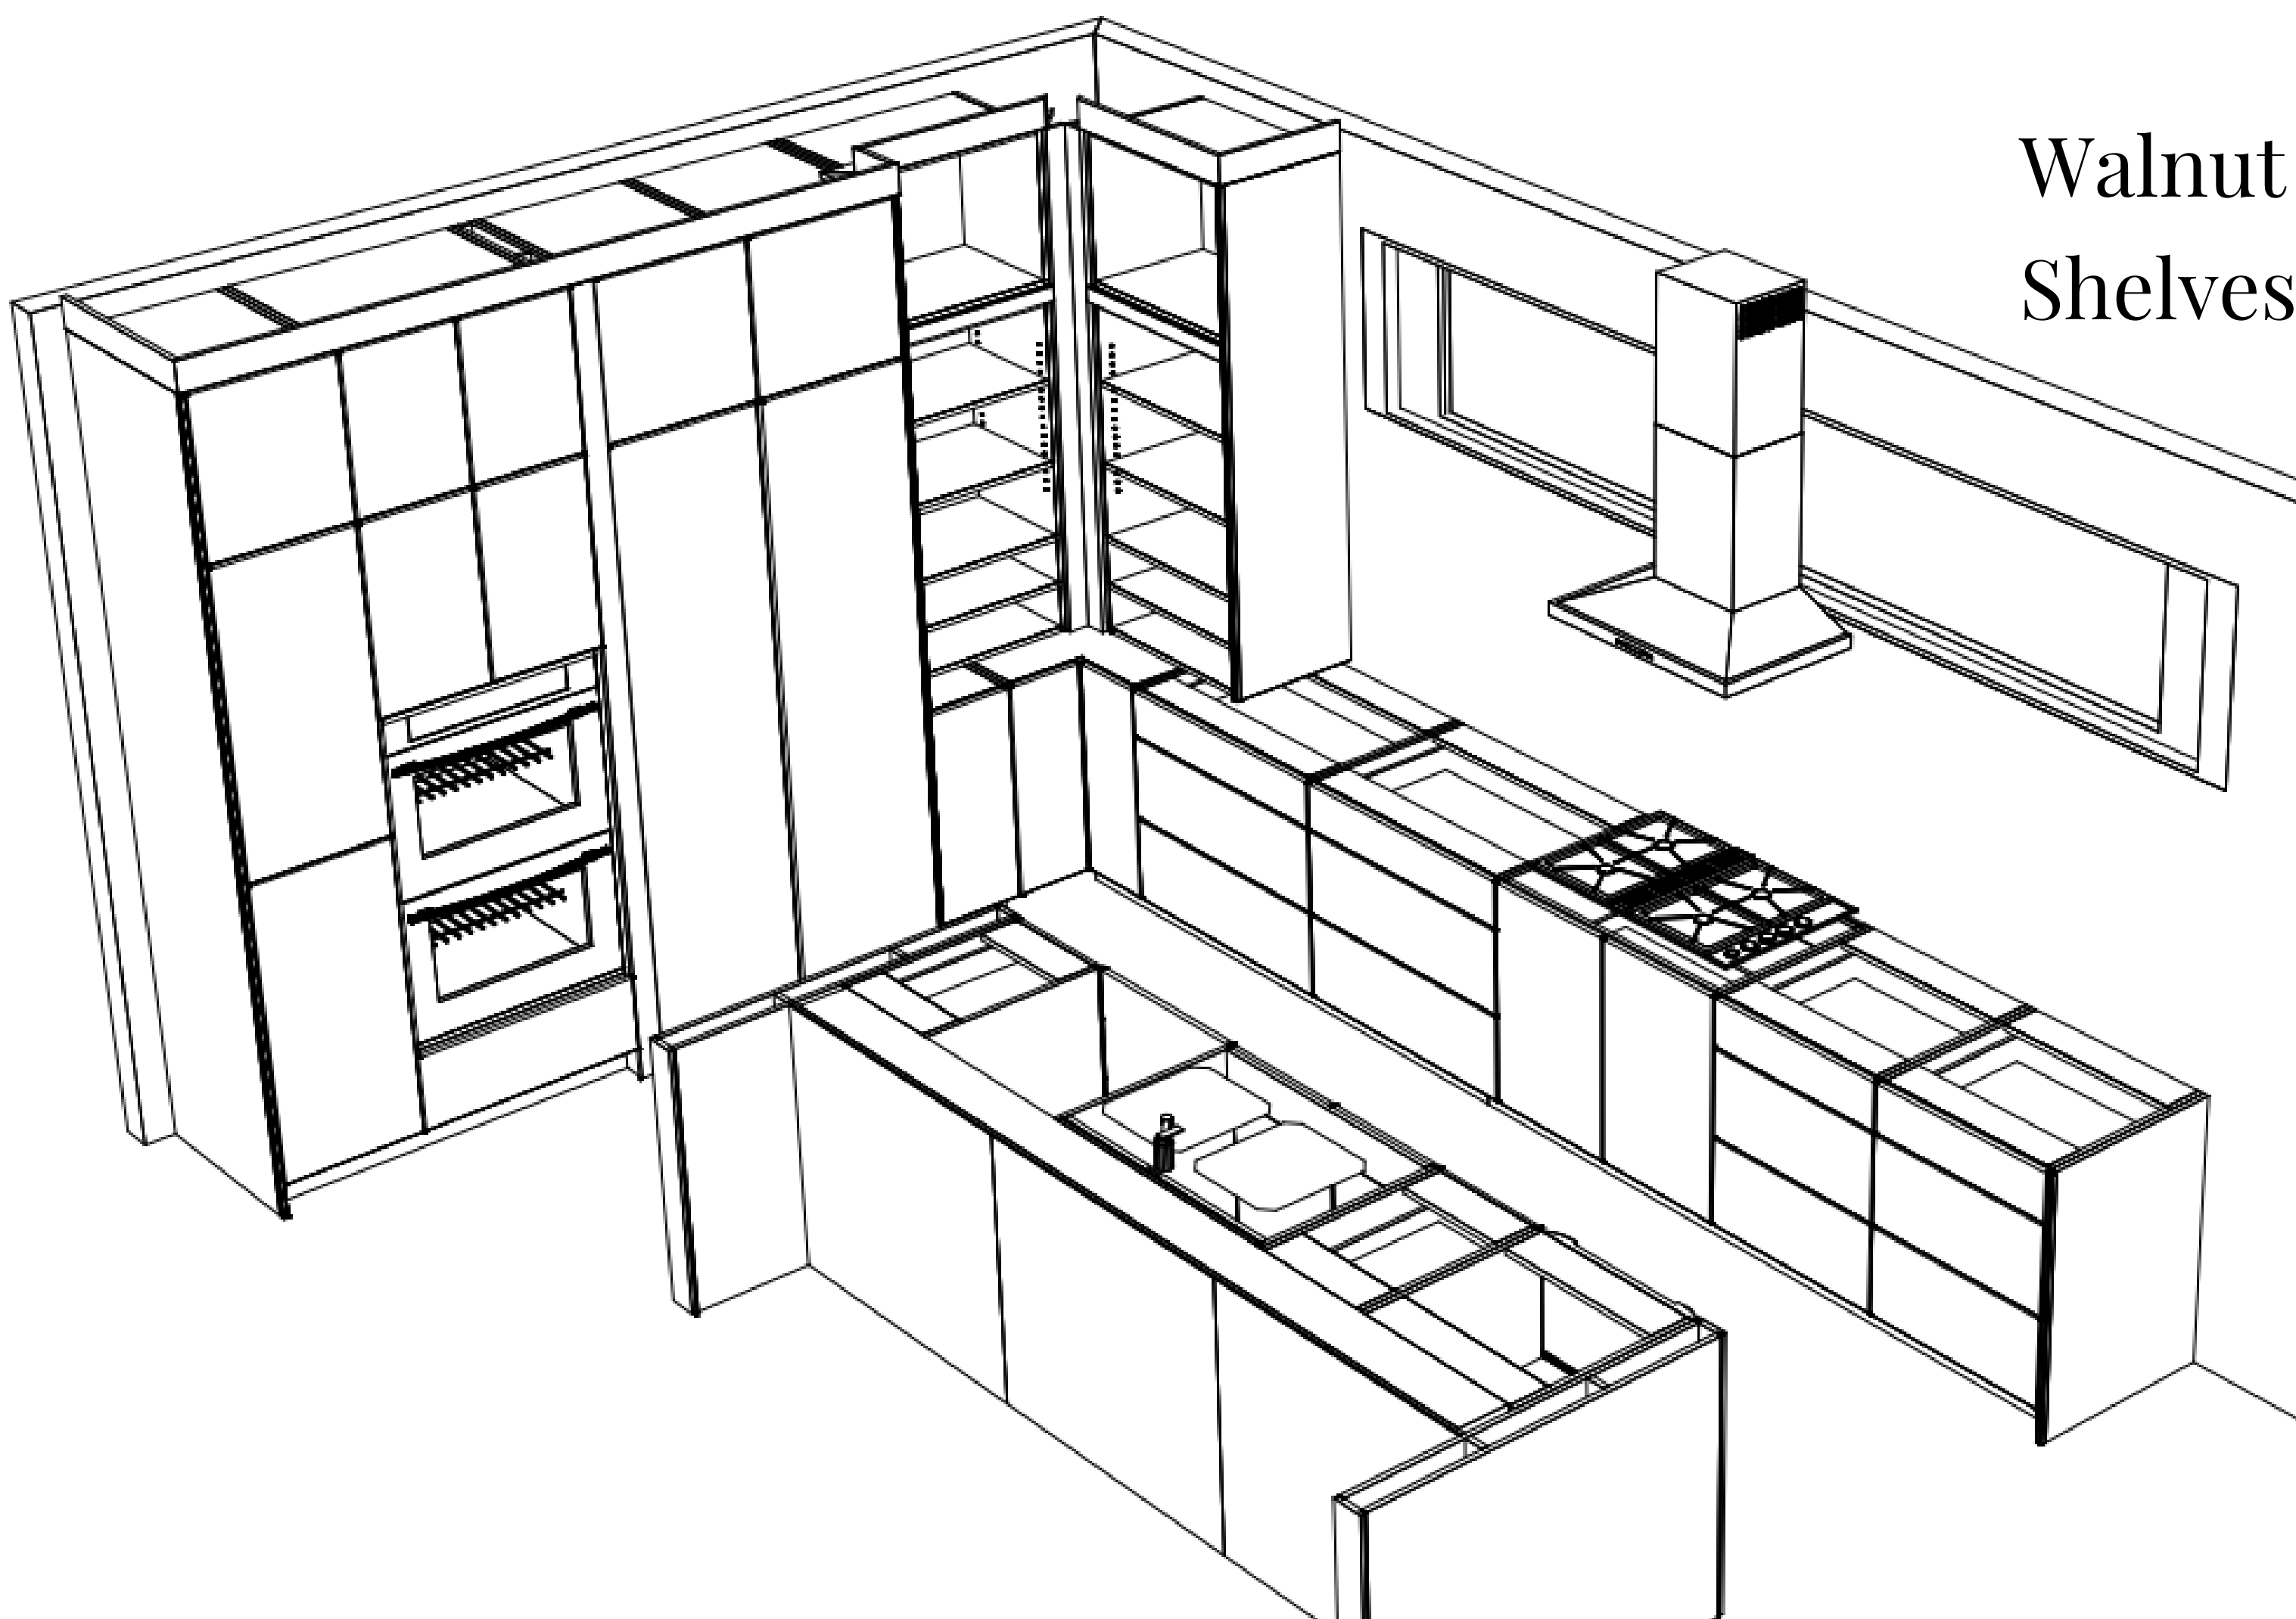

Walnut Floating
Shelves

Kitchen Design

APPLIANCES/PLUMBING/ LIGHTING

Dacor Appliance Package



Induction Cooktop



Double Oven with
Convection



Micro Drawer



Beverage Center



Panel Ready Fridge



Island Pendants




Range Hood

Plumbing Fixtures
Farmhouse Sink
Moen Faucet




LIVING/DINING

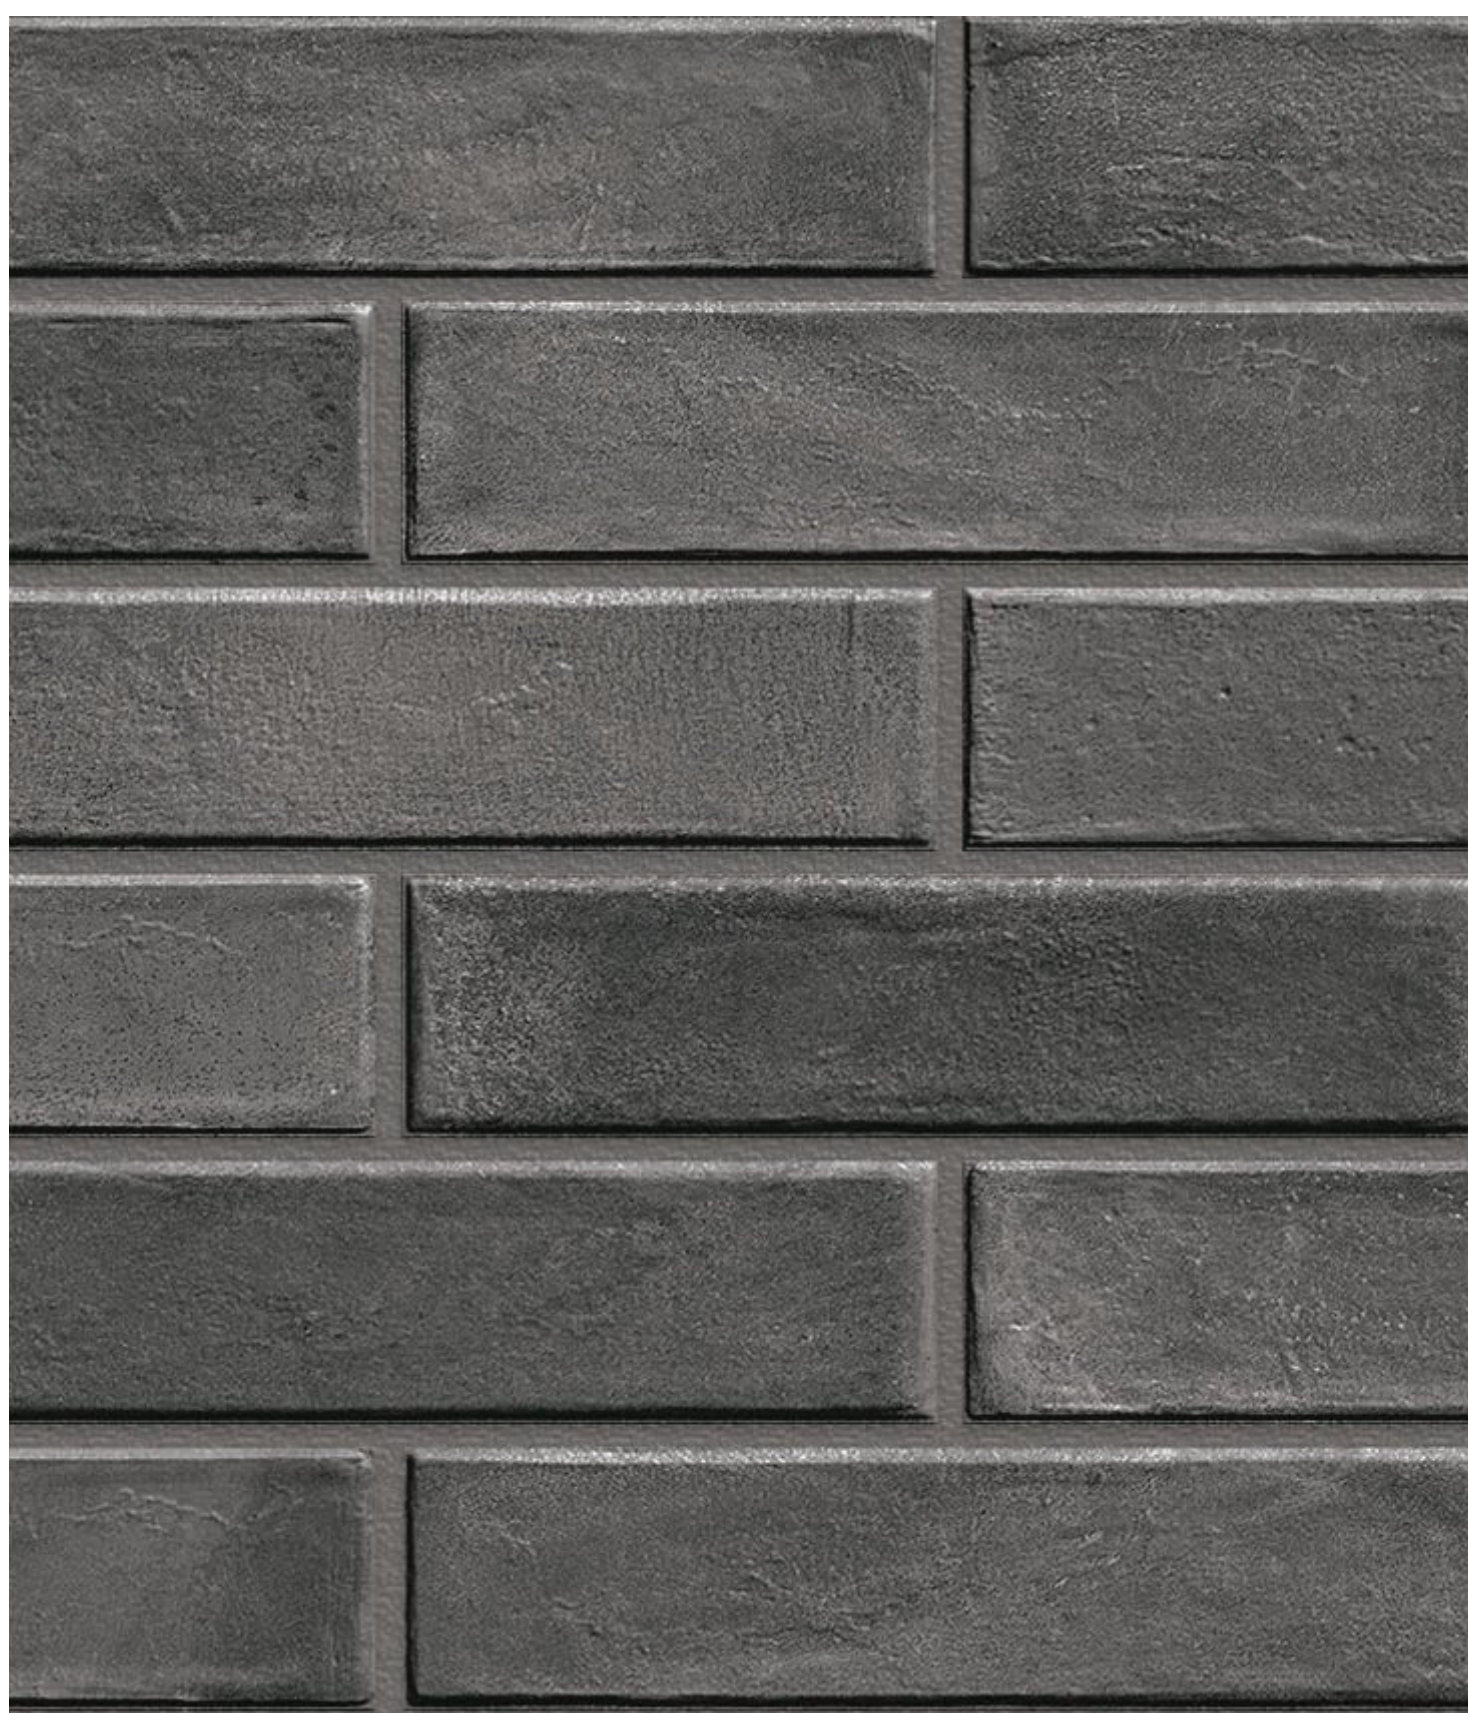

Procelain Brick Tile
Fireplace Surround




Three Sided Fireplace

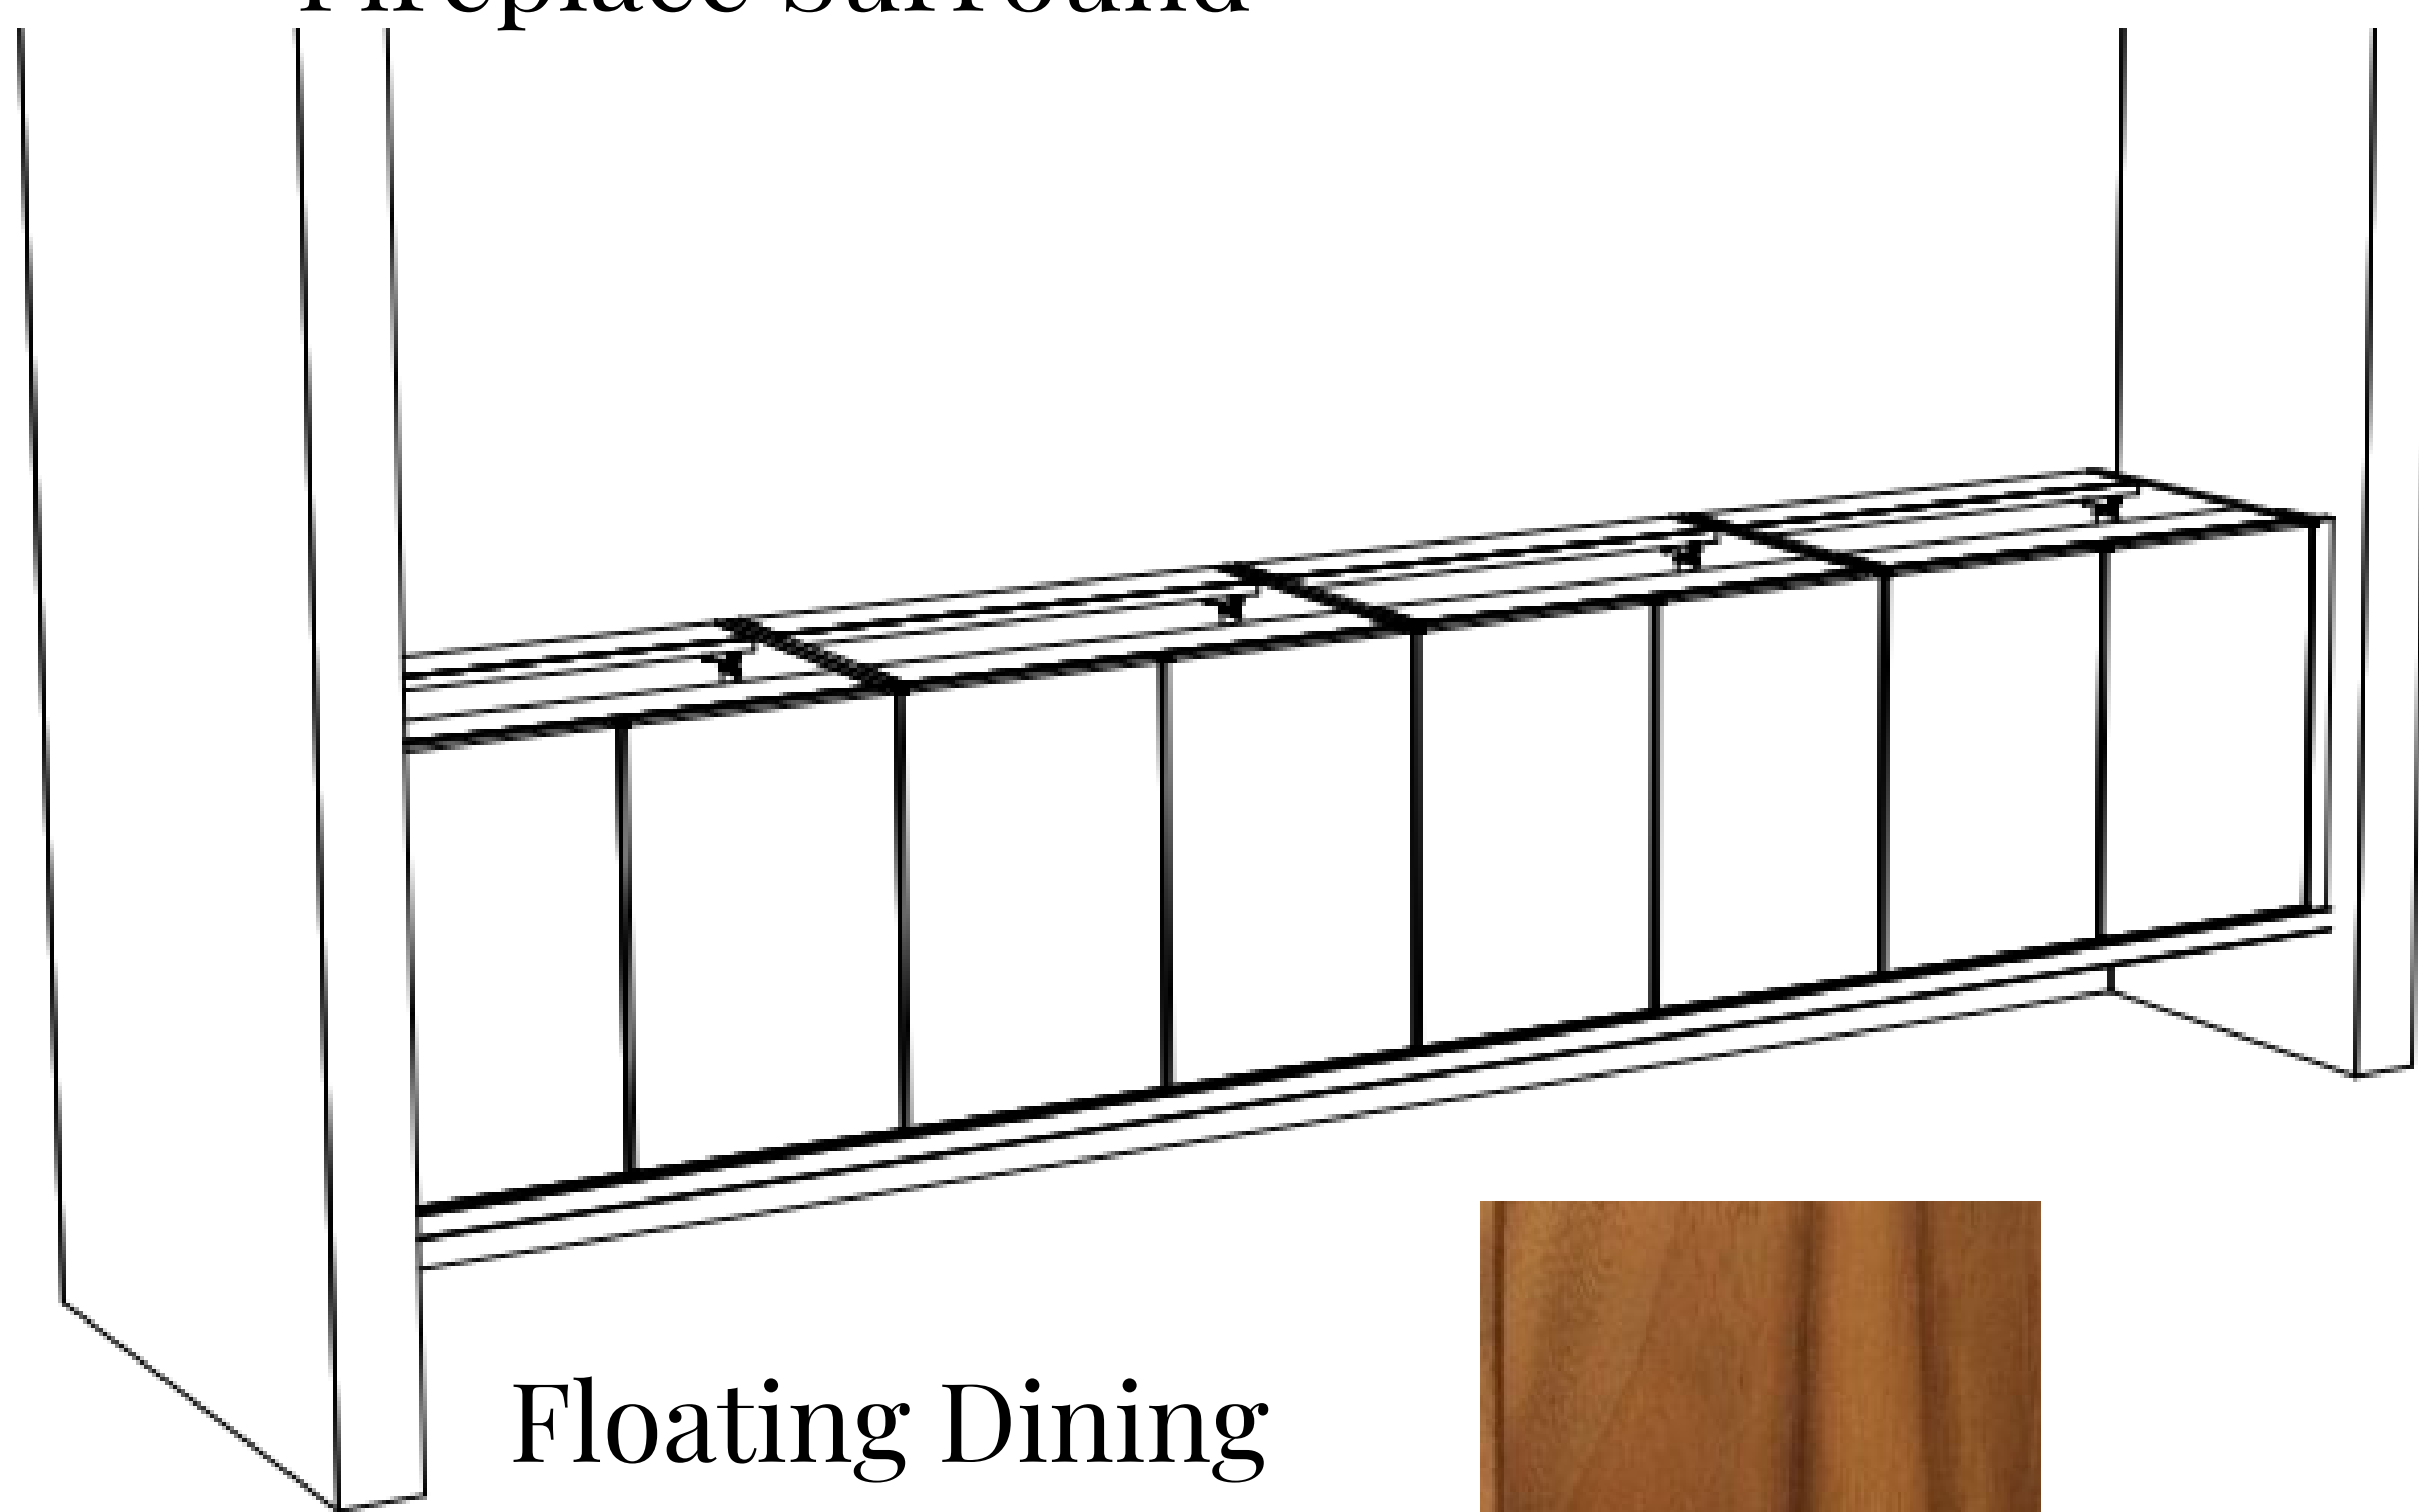


Floating Dining
Hutch Walnut
Cabinets



Blk Quartzite
Countertop

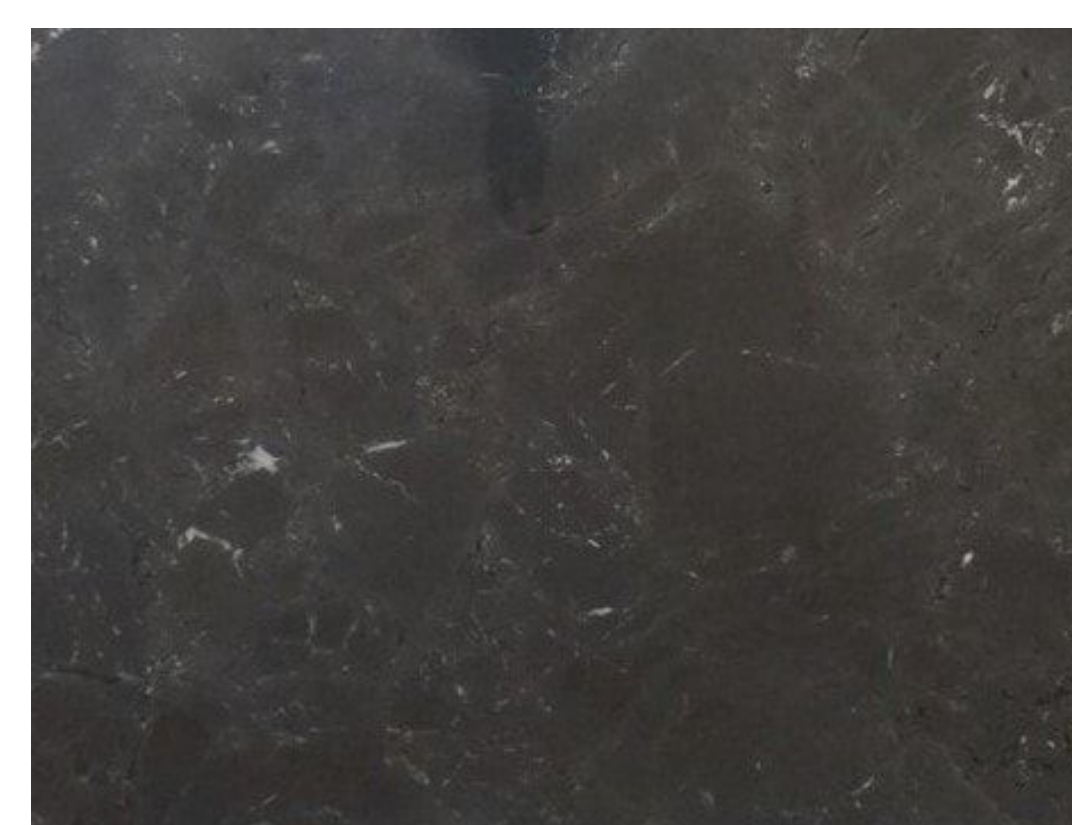


LVP Flooring

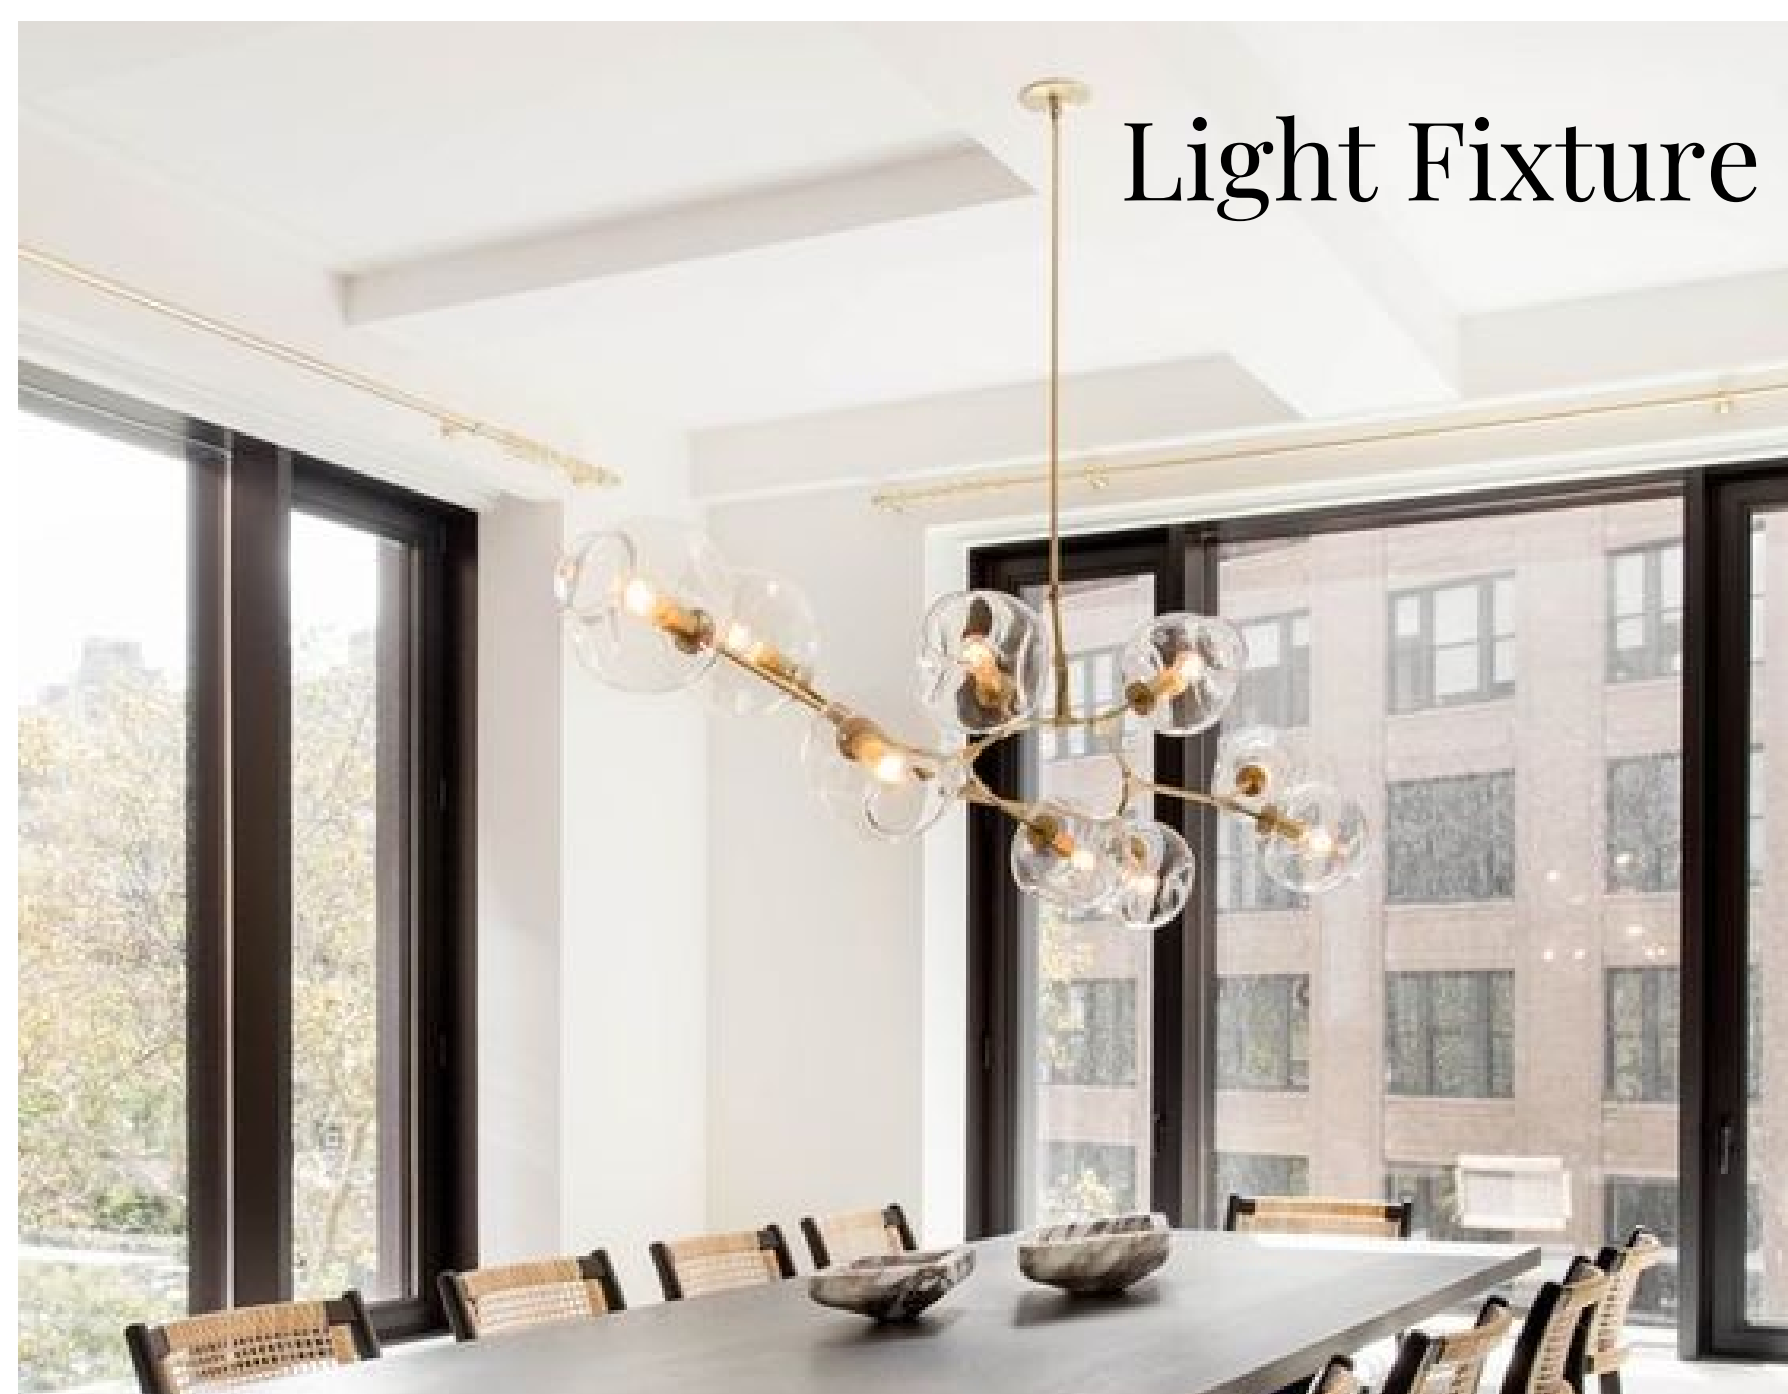

Light Fixture

PRIMARY BATHROOM

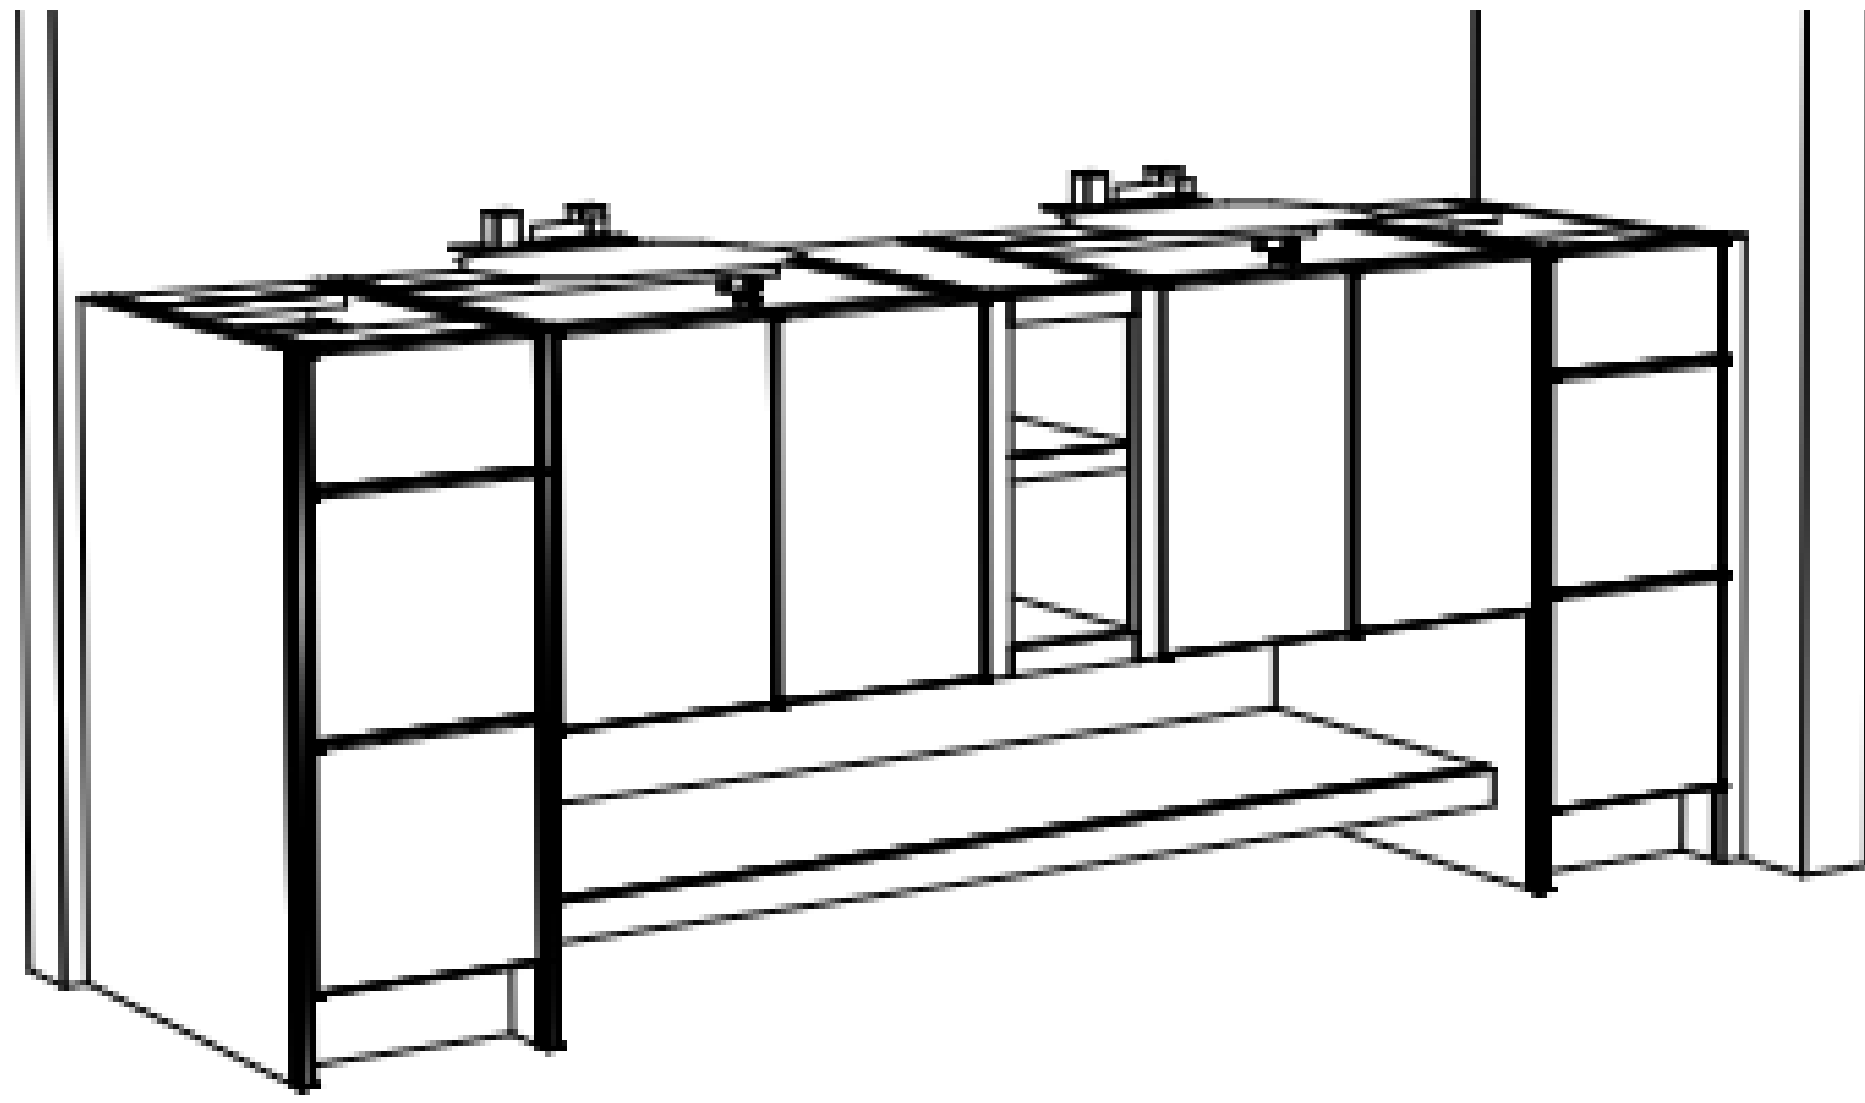



Cabinets




Leathered Quartz




Shower Inspiration

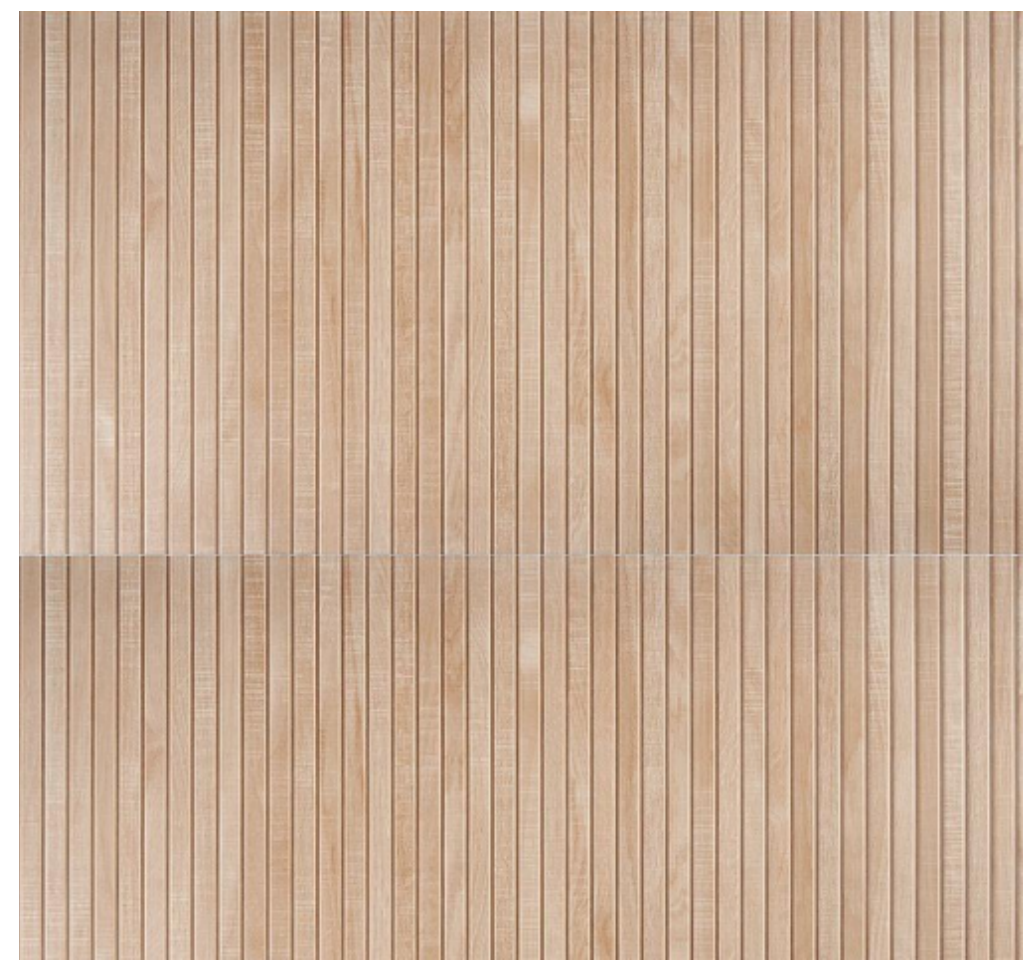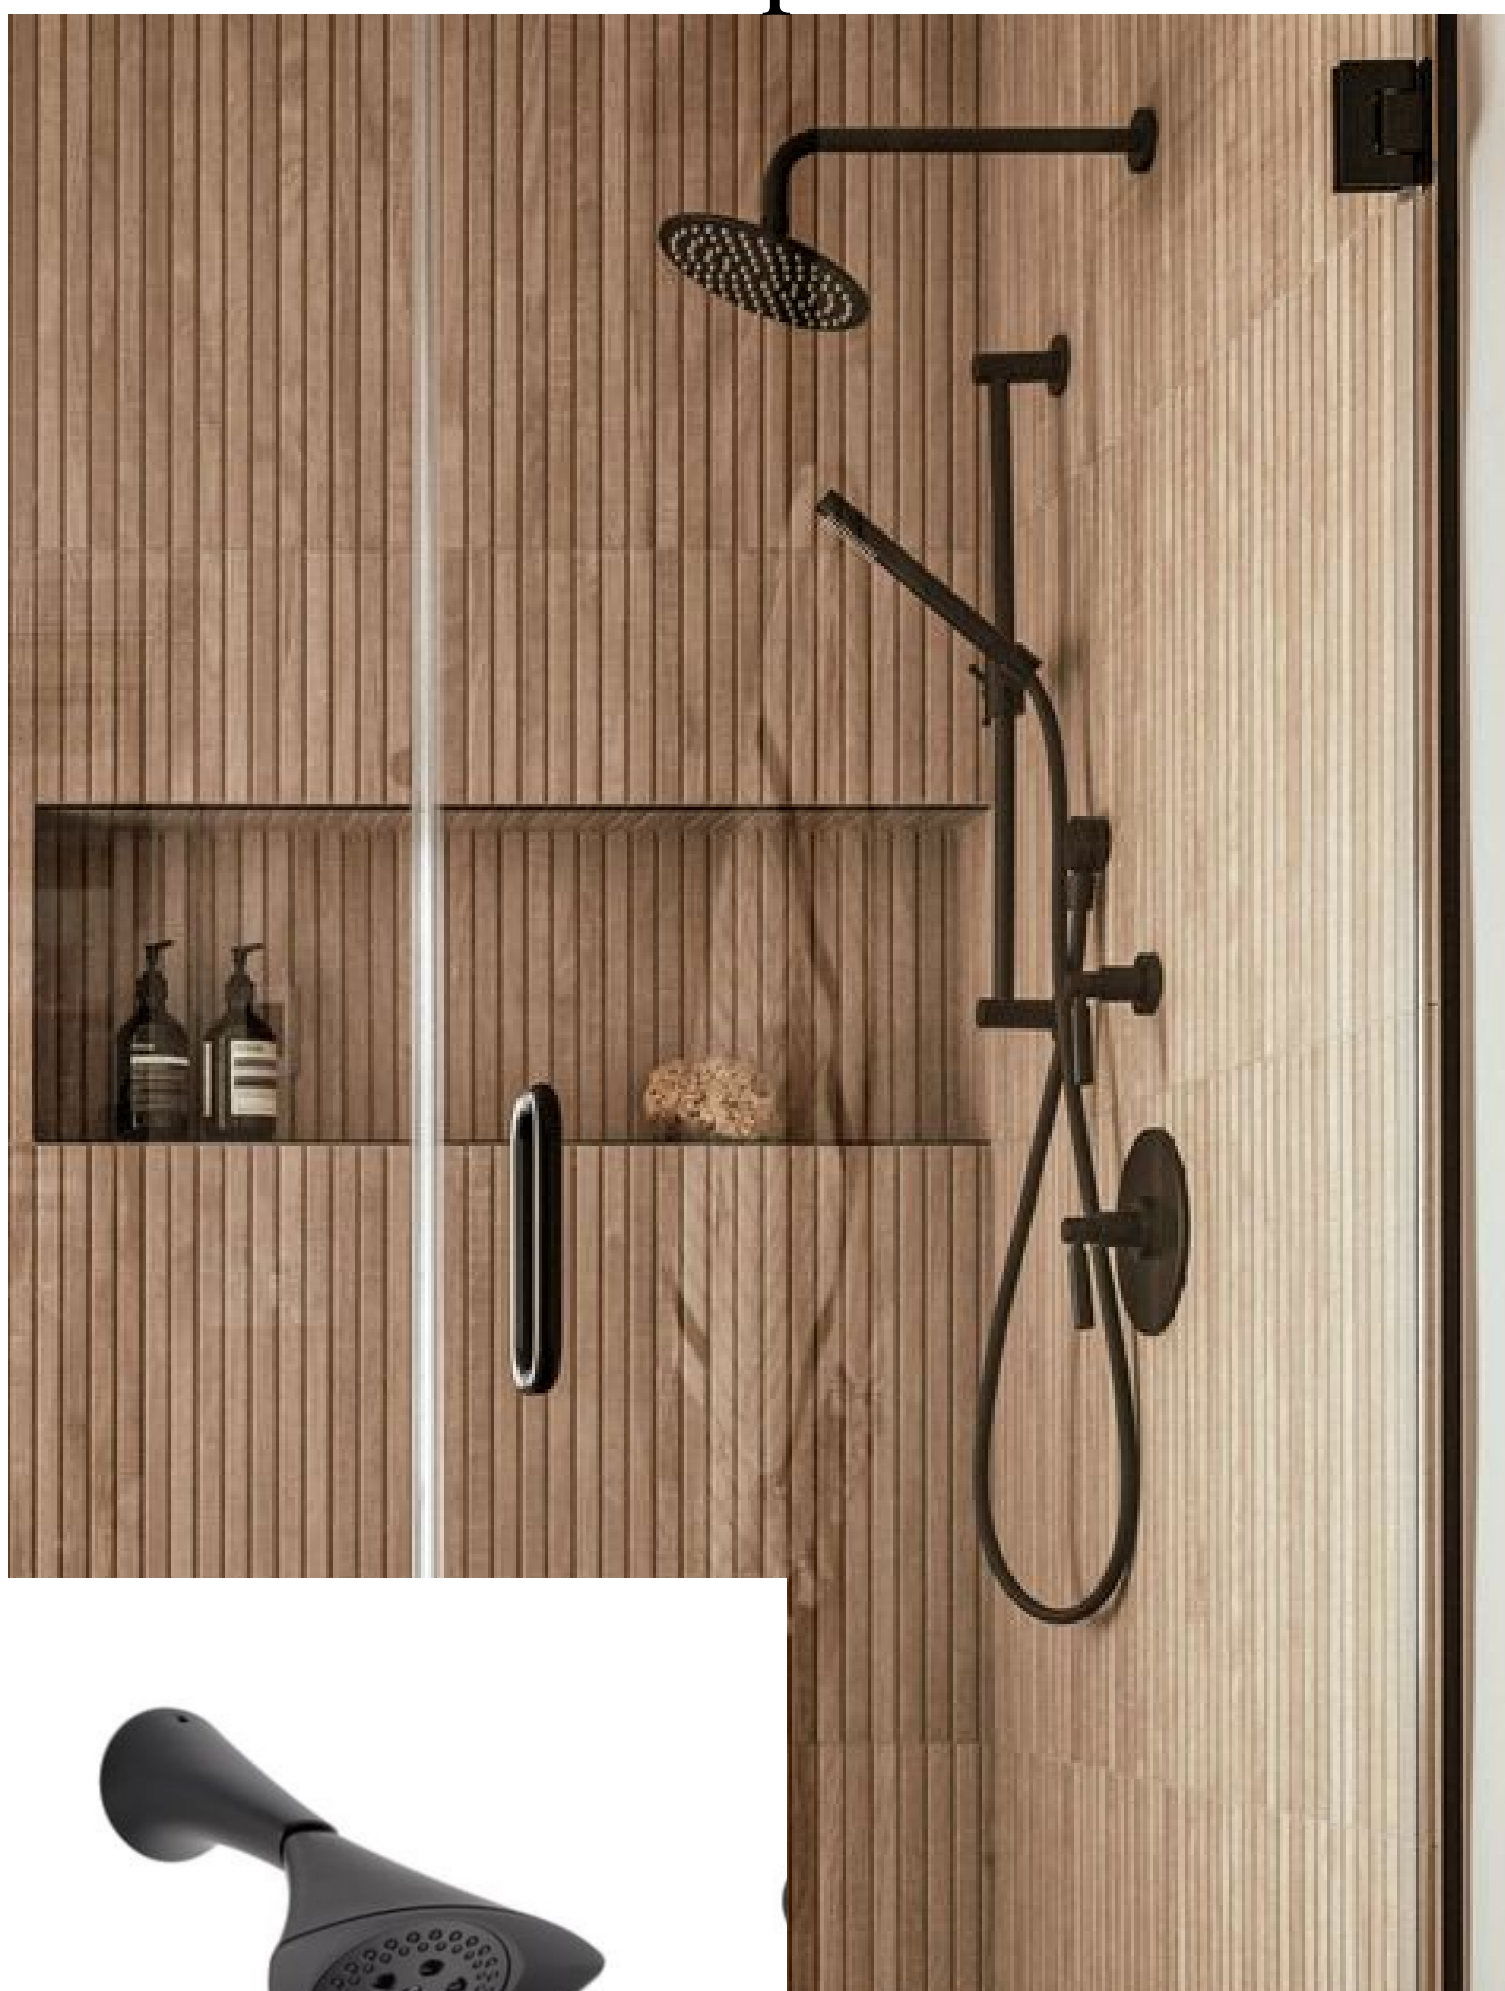

Shower Drain
Pure Matte Black

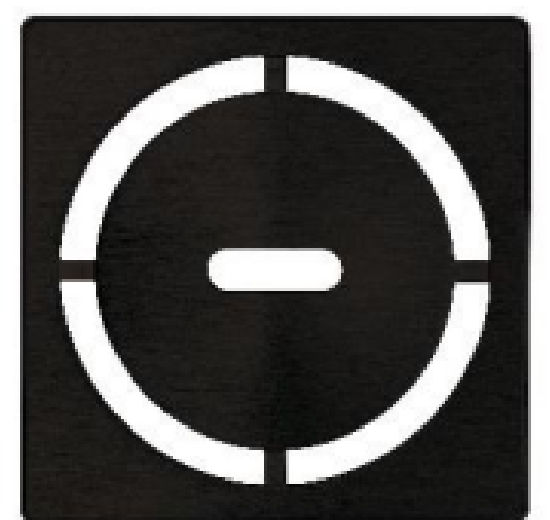

Floor, Shower Right Wall & Vanity
24"x 24" N2LA-Malibu White

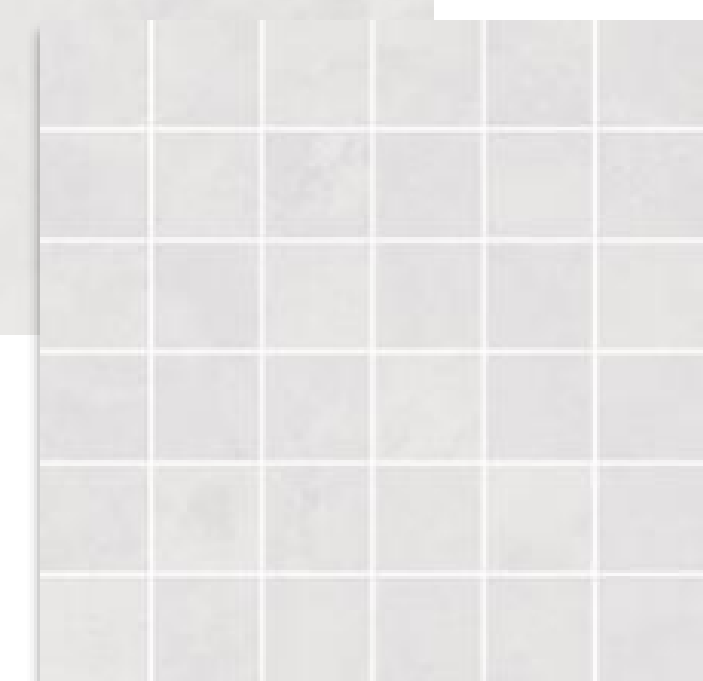

Shower Floor
2"x 2" N2LA-Malibu White